
 
 

 
 
 

 
 
 

 
 
 

 
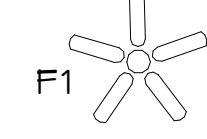

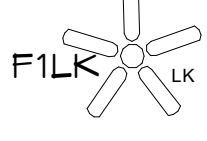
 

 

 






 

 




 

 

 


# SYMBOLS LEGEND

 
 
 
 



## RCP

EXH 	EXHAUST VENT	VL 	TRACK LIGHT OR VANITY LIGHT
L1 	CEILING MOUNTED LIGHT FIXTURE	WL 	WALL-MOUNTED LIGHT FIXTURE
L 	CEILING MOUNTED DIRECTIONAL LIGHT	ES 	EMERGENCY EXIT SIGN
RC 	RECESSED CAN LIGHT	EL 	EMERGENCY EXIT LIGHT
EYE 	EYEBALL OR SMALL CAN LIGHT	EEL 	EMERGENCY EXIT LIGHT W/ SIGN
HPL 	PENDANT LIGHT	STAIR 	LIGHTED STAIR SIGN
FL 	INDIVIDUAL FLUOR. LAY-IN FIXTURE 4 BULB	F 	FLOOD LIGHT
FL2 	INDIVIDUAL FLUOR. HANGING FIXTURE 2 BULB	PC 	PHOTO CELL
FL3 	INDIVIDUAL FLUOR. FLUSH MOUNT FIXTURE 4 BULB	F1 	CEILING FAN
C 	CAMERA	FILK 	CEILING FAN W/ LIGHT KIT
M 	MOTION DET.	7-2-6	CEILING HEIGHT AND TRIM 7'-2" ABOVE FLOOR BELOW WITH 6" CROWN MOULDING. NOTE: ALL CEILINGS NOT LABELED ARE PLASTER. CEILINGS SHOWN WITH A GRID ARE LAY IN ACOUSTICAL TILE.
SUP 	SUPPLY VENT	J 	JUNCTION BOX
SUP2 	SUPPLY VENT		
RET 	RETURN VENT		
RET2 	RETURN VENT		
spe 	SPEAKER		

 

 



## ELECTRIC

DAT 	DATA OUTLET
TEL 	TELEPHONE JACK
S1 	ELECTRIC SWITCH
TV 	CABLE TELEVISION OUTLET
P1 	DUPLEX RECEPTACLE OUTLET
P3 	SPECIAL PURPOSE CONNECTION OR OUTLET
PQ 	QUADRUPLX RECEPTACLE OUTLET
PF 	FLOOR DUPLEX RECEPTACLE OUTLET
PNL 	ELECTRIC PANEL
MTR 	ELECTRIC METER
BUT 	BUTTON SWITCH
DISC 	DISCONNECT SWITCH
LG 	GROUND/FLOOR LIGHT
KP 	KEY PAD



## FIRE PROTECTION




FE 	FIRE EXTINGUISHER
FP 	FIRE PULL
AS 	FIRE ALARM (HORN/SRTOBE)
SD 	SMOKE DETECTOR
SS 	SMOKE ALARM SPEAKER
SP 	SPRINKLER HEAD CEILING MOUNT
SPW 	SPRINKLER HEAD WALL MOUNT

## MEP

TH 	THERMOSTAT
FD 	FLOOR DRAIN
V 	VALVE
HB 	HOSE BIB
WS 	WATER SUPPLY
HEAT 	SUSPENDED GAS HEATER

## MISC

BOLLARD 	BOLLARD
ELEVATION SYMBOL 	11-4-11/16 SPOT ELEVATION

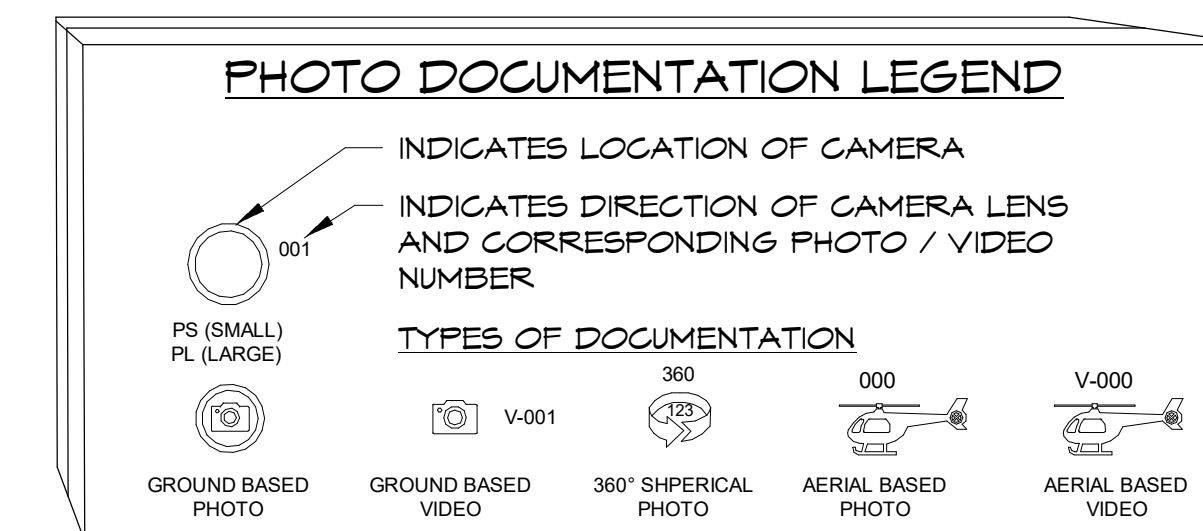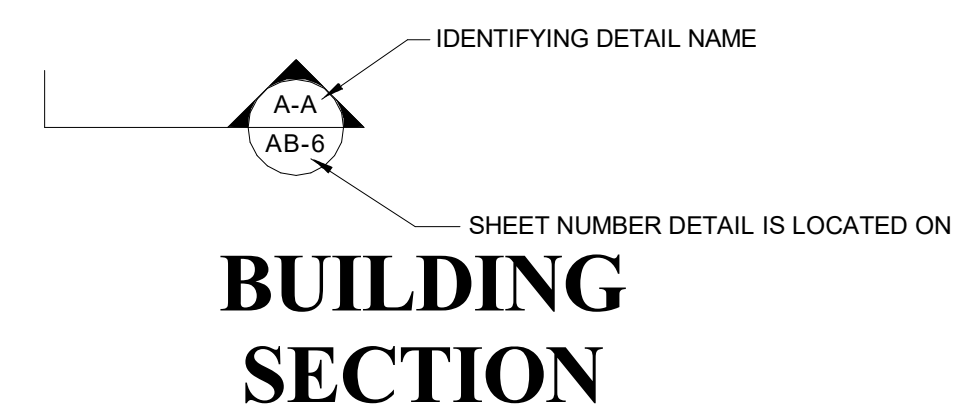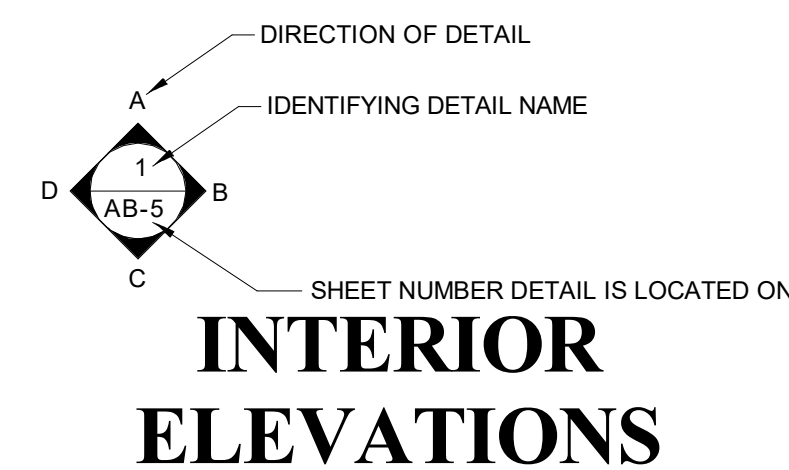

**ARCHITECTURAL AS BUILT**  
**Point Reyes Station, CA**

01	100% SUBMISSION	SEE COVER SHEET
NO.	ISSUES / REVISIONS	DATE

## SYMBOL LEGEND

Designer	PROJECT MANAGER
Designer	PROJECT DIRECTOR
Project Number	PROJECT NUMBER
Author	DRAWN BY
	SHEET NUMBER

**OSL**


INTERIOR FINISH SCHEDULE				
Room	Floor Finish	Wainscot	Wall Finish	Ceiling Finish
CL	CPT		GWB	GWB
CLASSROOM 1	CPT		GWB	T-BAR
CLASSROOM 2	CPT		GWB	GWB
DATA	CPT		GWB	GWB
HALLWAY	CPT		GWB	GWB
KITCHEN	VINYL		GWB	GWB
LAUNDRY	GWB		GWB	GWB
LIVING	HDWD		GWB	GWB
OFFICE 1	CPT		GWB	GWB
OFFICE 2	CPT		GWB	T-BAR
PANTRY	HDWD		GWB	GWB
STOR.	CPT		GWB	GWB
STORAGE				
WC	TILE	TILE	GWB	

DOOR SCHEDULE				
Type	Count	Width	Height	Comments
A	16	3' - 0"	6' - 8"	
B	2	2' - 8"	6' - 8"	
C	2	8' - 0"	8' - 0"	
D	3	6' - 0"	6' - 8"	
E	1	2' - 6"	6' - 8"	
F	1	2' - 0"	6' - 8"	
G	1	12' - 0"	7' - 9"	
H	1	5' - 7"	6' - 5"	
J	1	2' - 4"	6' - 8"	
K	1	8' - 10"	6' - 10"	

WINDOW SCHEDULE				
Mark	Count	Width	Height	Operation
A	10	3' - 11"	3' - 11"	
B	2	2' - 11"	3' - 11"	
C	1	2' - 11"	2' - 11"	
D	1	4' - 11"	3' - 11"	



© 2020 AEC CONSULTANTS INC

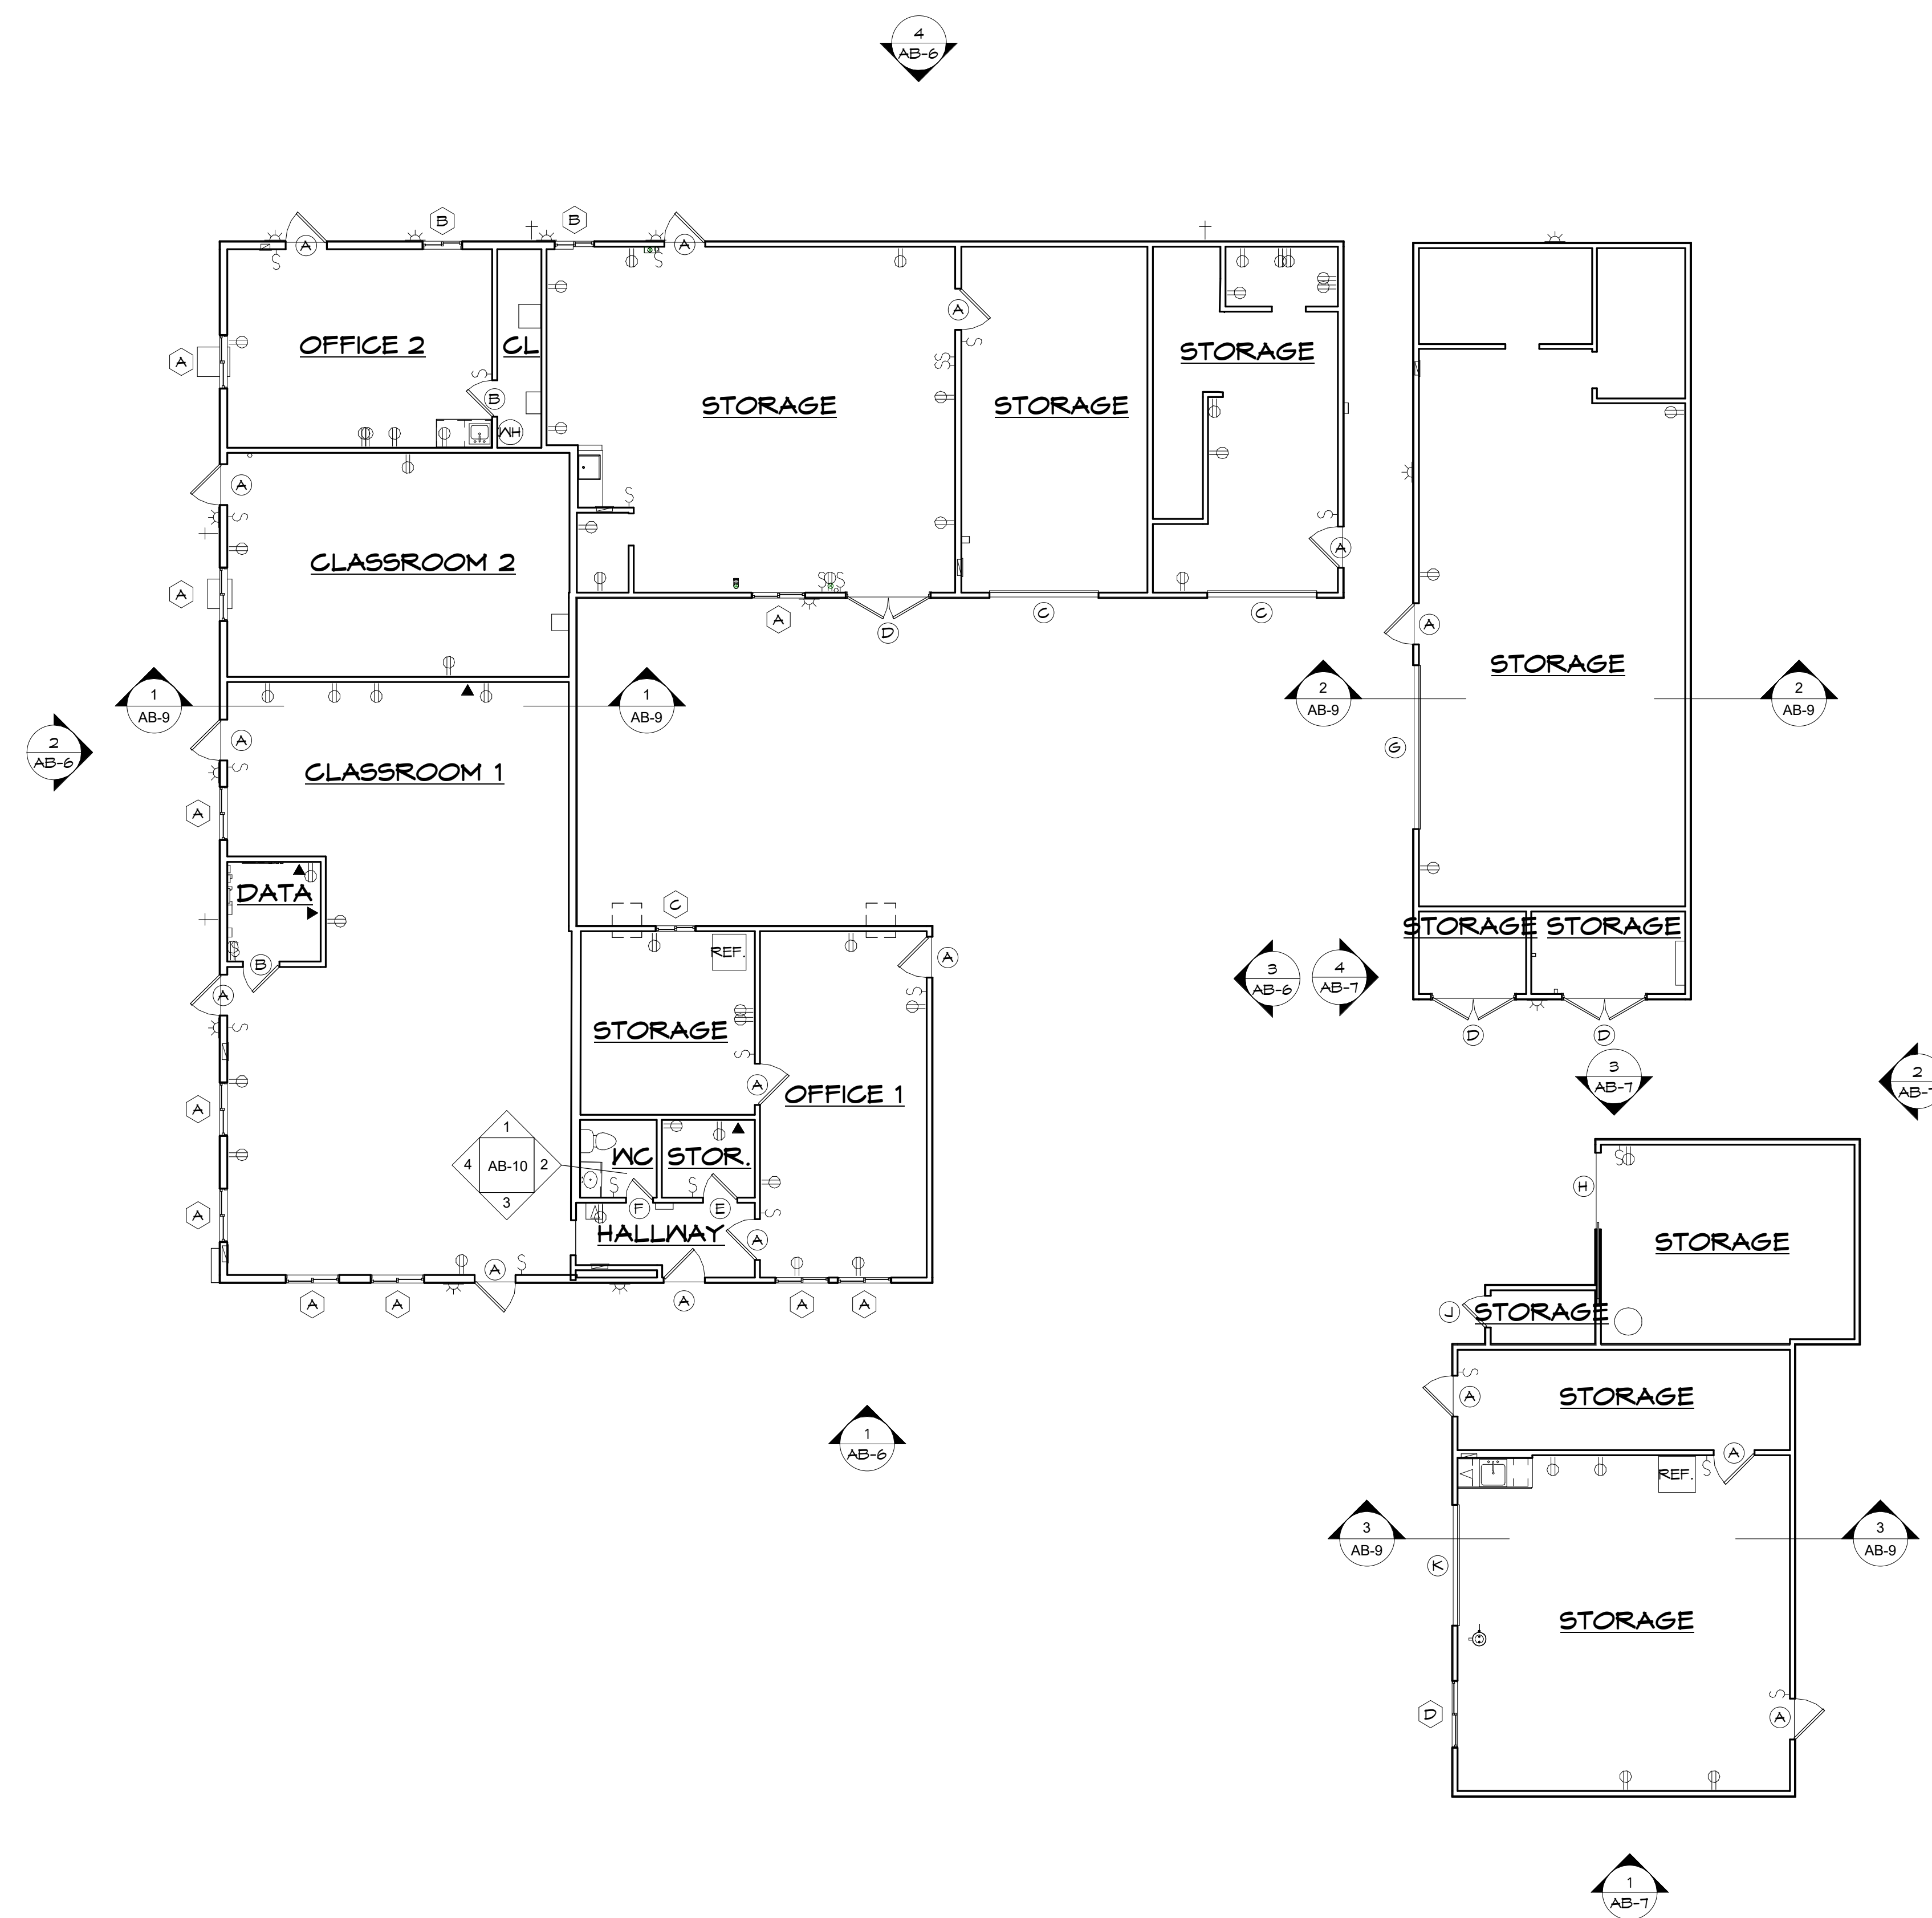

**1** FIRST FLOOR  
1/8" = 1'-0"

**ARCHITECTURAL AS BUILT**  
**Point Reyes Station, CA**

01	100% SUBMISSION	SEE COVER SHEET
NO.	ISSUES / REVISIONS	DATE
SHEET TITLE		

**FIRST FLOOR**

Designer	PROJECT MANAGER
Designer	PROJECT DIRECTOR
Project Number	PROJECT NUMBER
Author	DRAWN BY
	SHEET NUMBER

**AB-1**

**ARCHITECTURAL AS BUILT**  
**Point Reyes Station, CA**



**1** FIRST FLOOR  
 1/8" = 1'-0"

NO.	ISSUES / REVISIONS	DATE	SHEET TITLE
01	100% SUBMISSION		SEE COVER SHEET


**1ST FLR REFLECTED  
 CEILING PLAN**

Designer	PROJECT MANAGER
Designer	PROJECT DIRECTOR
Project Number	PROJECT NUMBER
	SCALE
Author	DRAWN BY
	SHEET NUMBER

**AB-3**



**ARCHITECTURAL AS BUILT**  
**Point Reyes Station, CA**

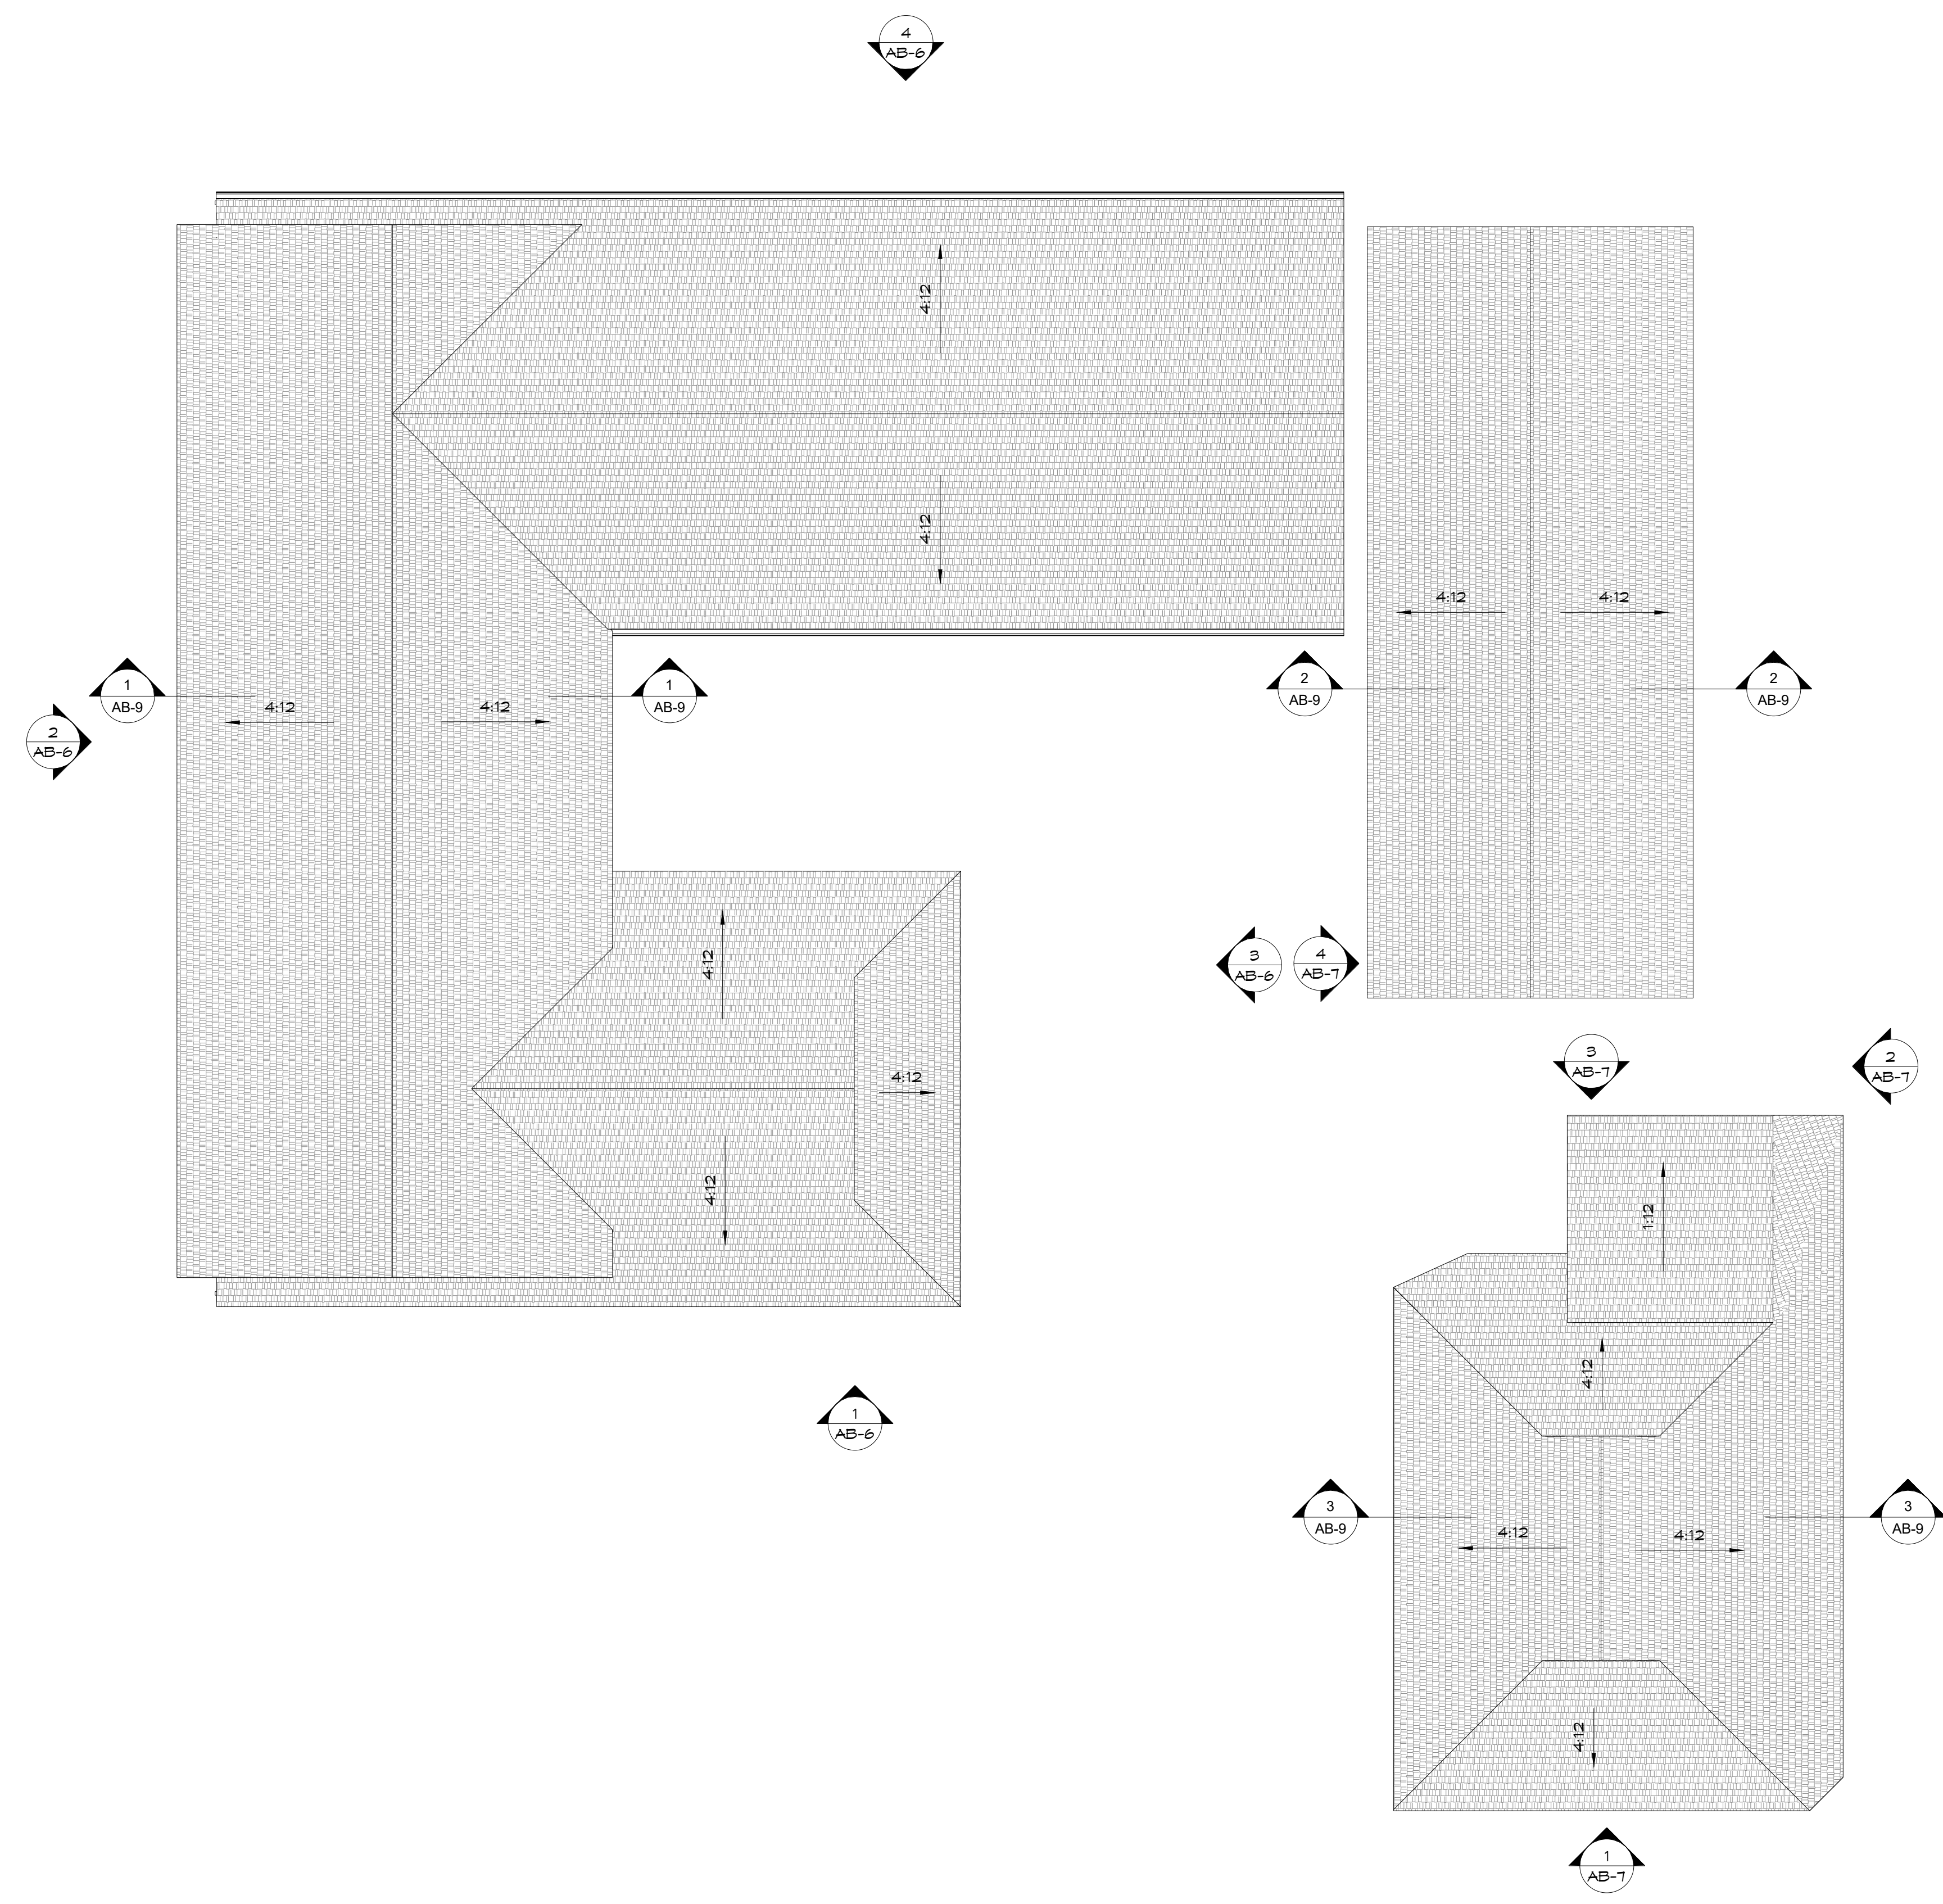

**1 ROOF PLAN**  
1/8" = 1'-0"

01	100% SUBMISSION	SEE COVER SHEET
NO.	ISSUES / REVISIONS	DATE
		SHEET TITLE

<b>ROOF PLAN</b>	
Designer	PROJECT MANAGER
Designer	PROJECT DIRECTOR
Project Number	PROJECT NUMBER
	SCALE
Author	DRAWN BY
	SHEET NUMBER

**AB-5**




**EXTERIOR FINISH SCHEDULE**

Asphalt Shingle
Lap Siding
Siding - Metal
Stucco

TOP OF RIDGE  
14' - 11"


FIRST FLOOR  
0' - 0"

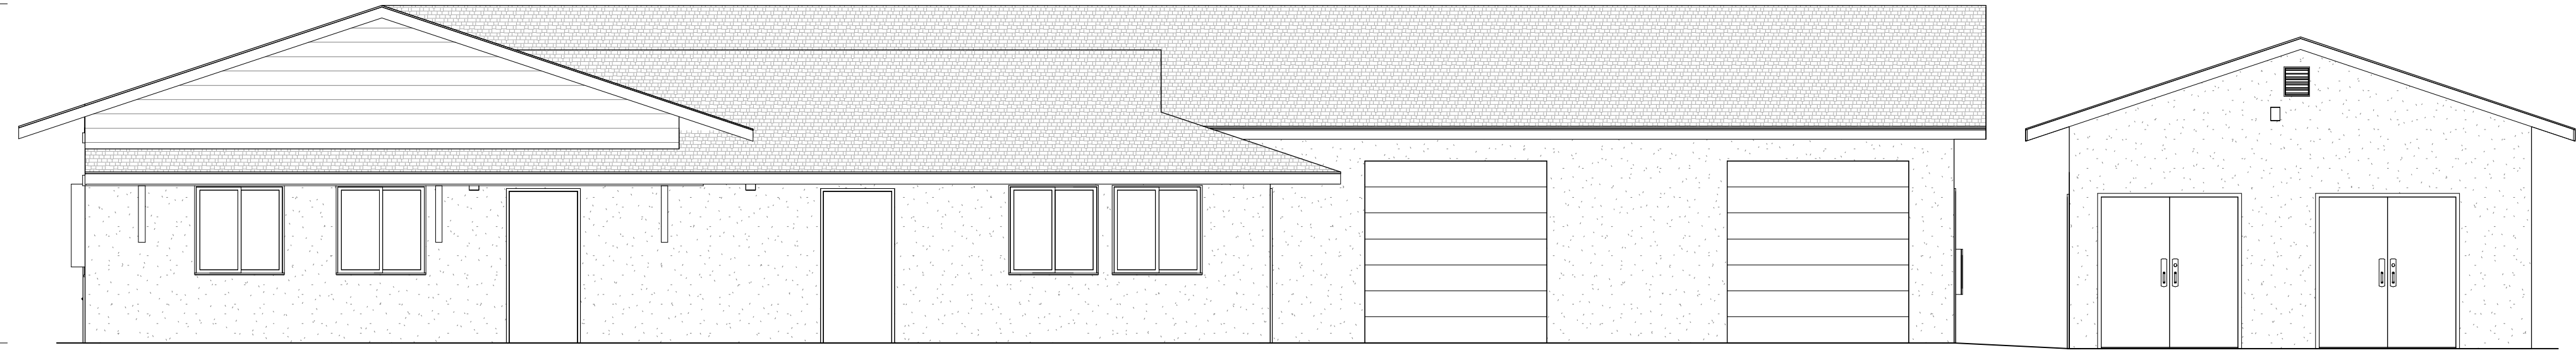

1 FRONT  
3/16" = 1'-0"

TOP OF RIDGE  
14' - 11"


FIRST FLOOR  
0' - 0"

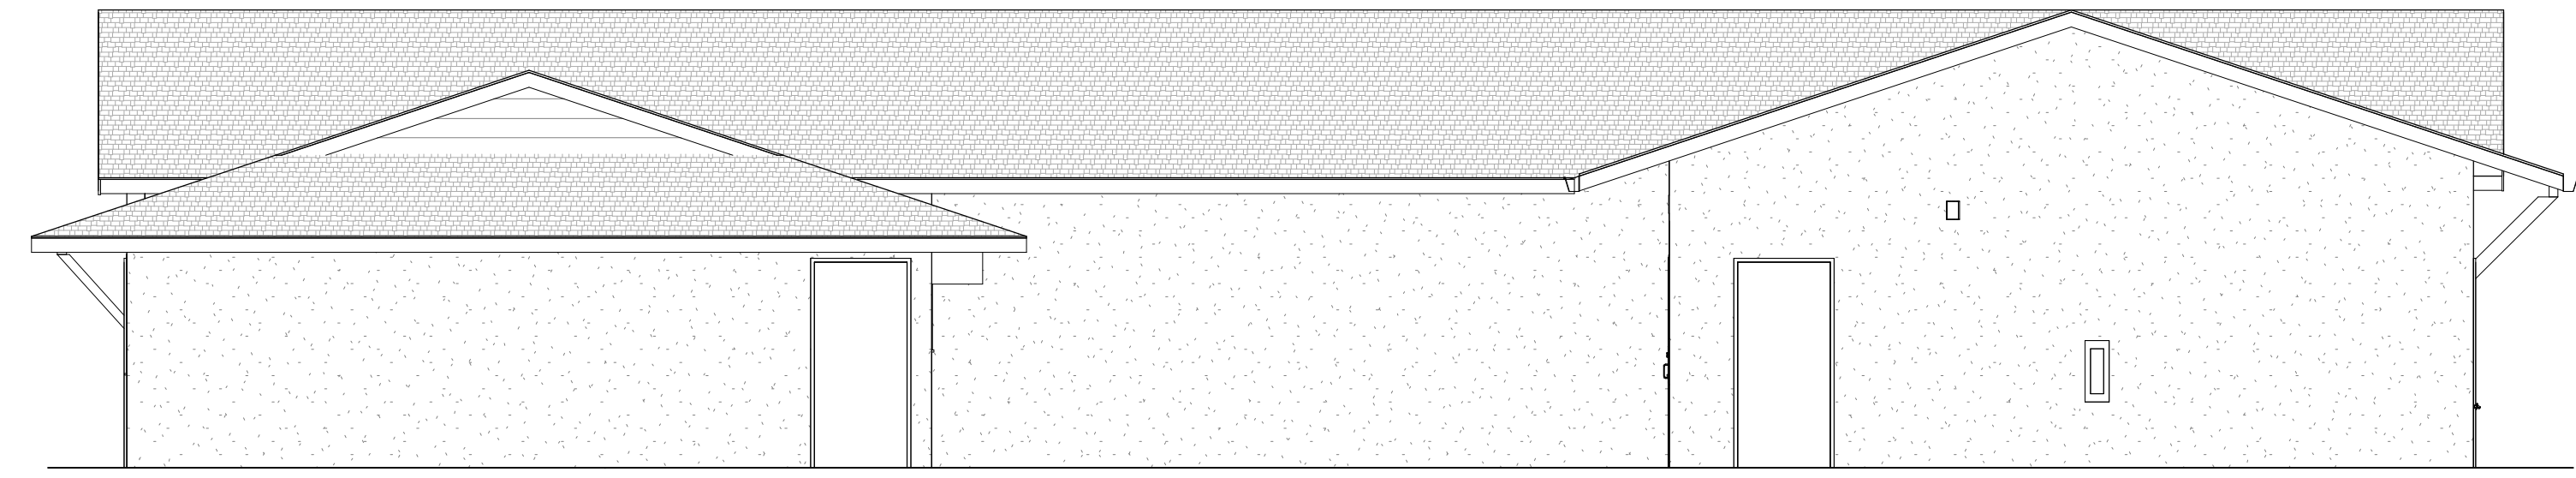

3 RIGHT  
3/16" = 1'-0"

TOP OF RIDGE  
14' - 11"


FIRST FLOOR  
0' - 0"

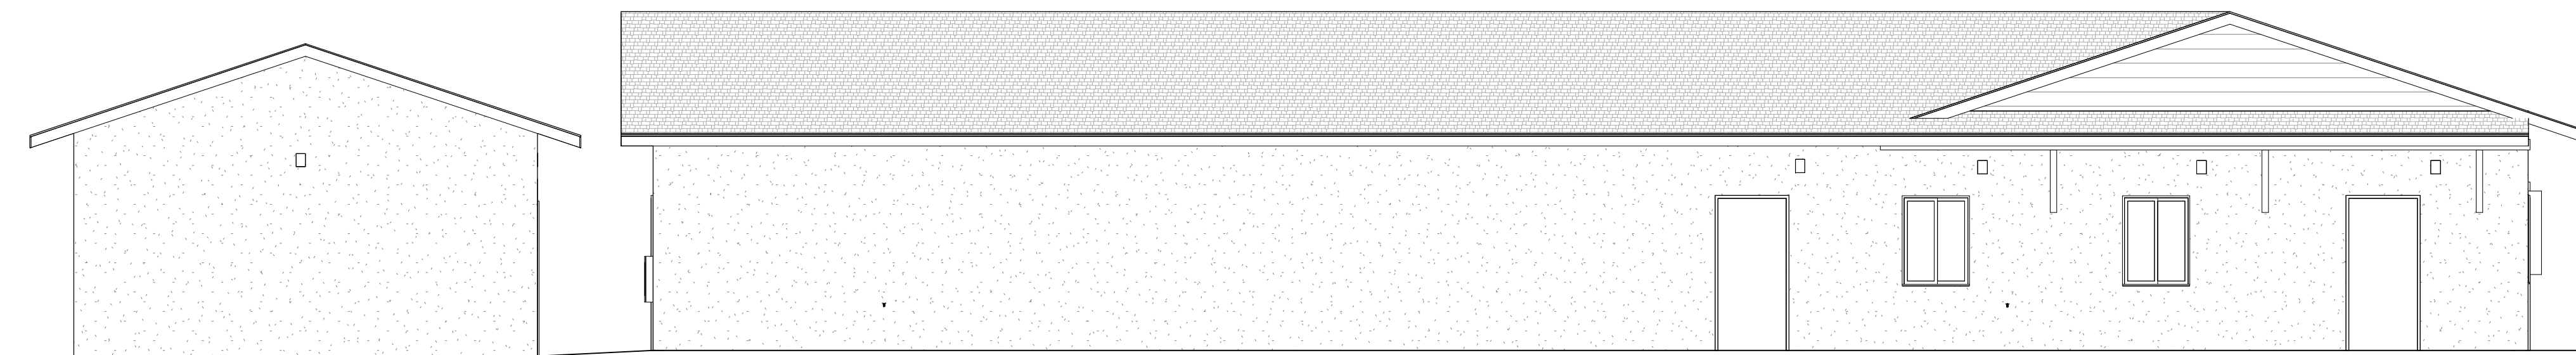

4 BACK  
3/16" = 1'-0"

TOP OF RIDGE  
14' - 11"

FIRST FLOOR  
0' - 0"

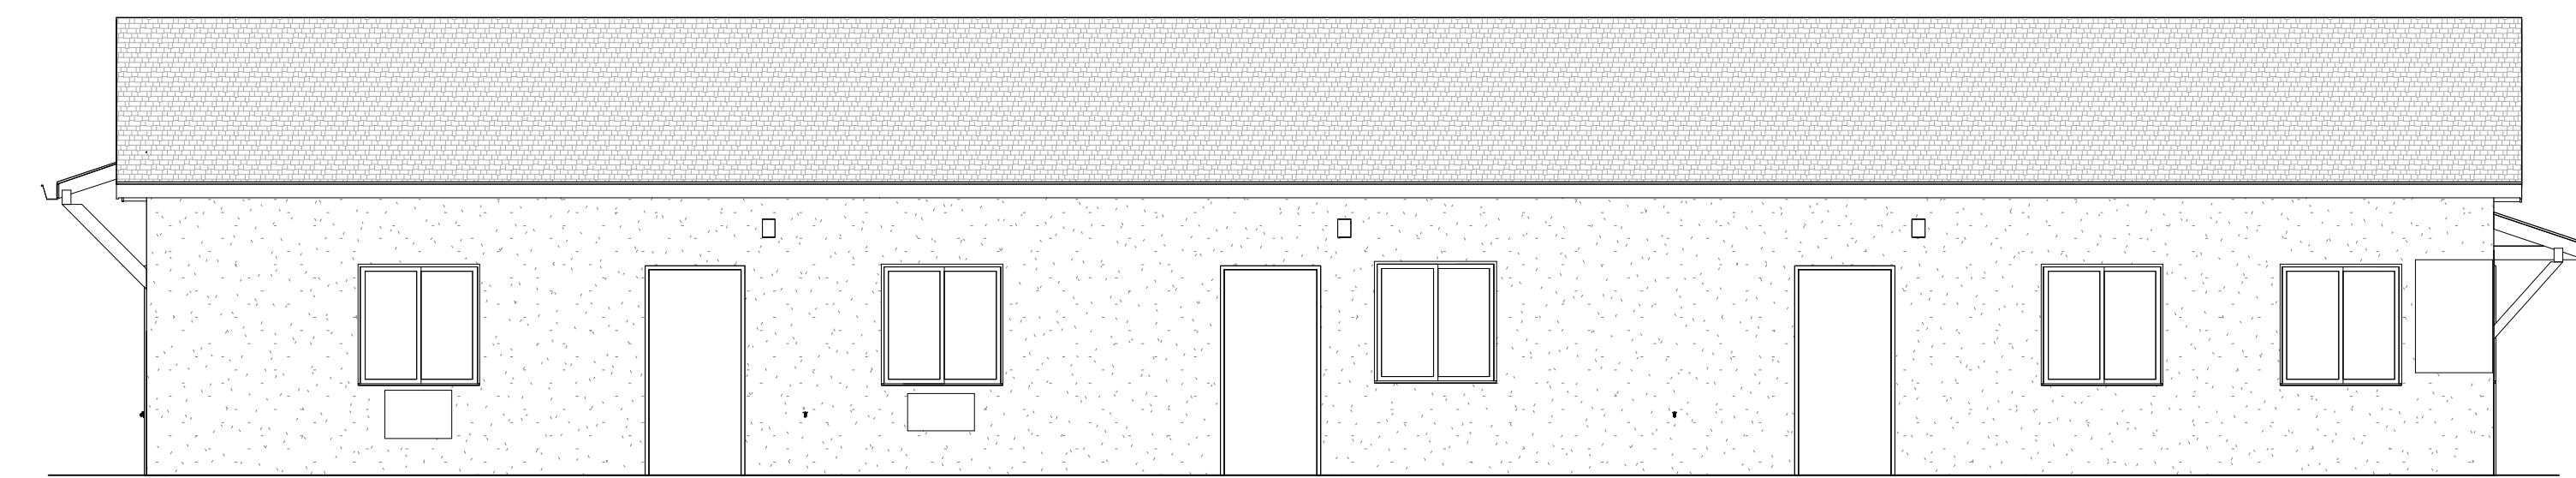

2 LEFT  
3/16" = 1'-0"

**AS BUILT**  
PROFESSIONALS  
www.asbuiltprofessionals.com



© 2020 AEC CONSULTANTS INC


**ARCHITECTURAL AS BUILT**  
**Point Reyes Station, CA**

01	100% SUBMISSION	SEE COVER SHEET
NO.	ISSUES / REVISIONS	DATE


**EXTERIOR ELEVATIONS**

Designer	PROJECT MANAGER
Designer	PROJECT DIRECTOR
Project Number	PROJECT NUMBER
Author	DRAWN BY
	SHEET NUMBER


**AB-6**

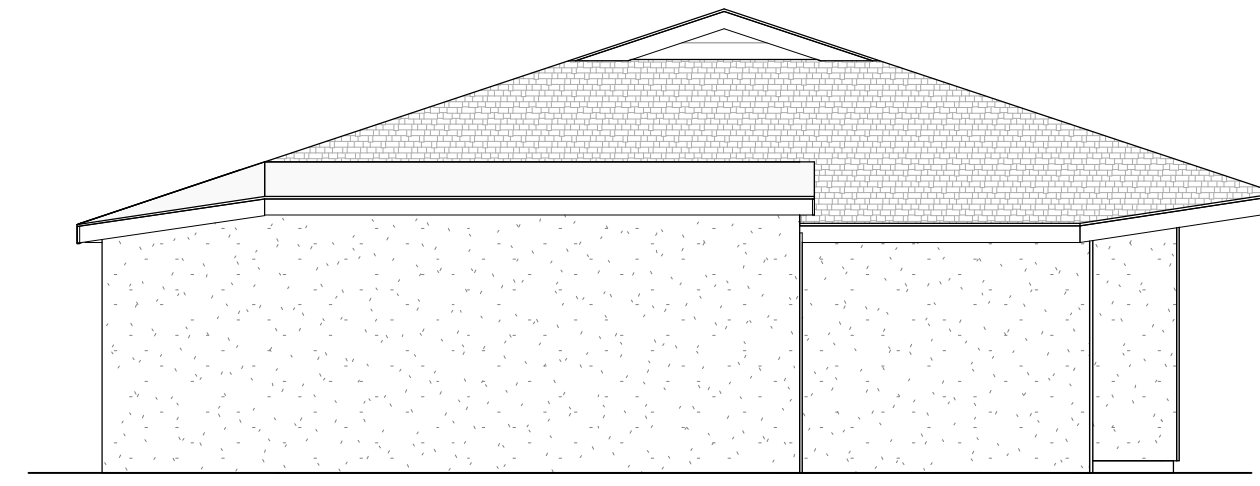


**3 BUILDING 3 BACK**  
 3/16" = 1'-0"

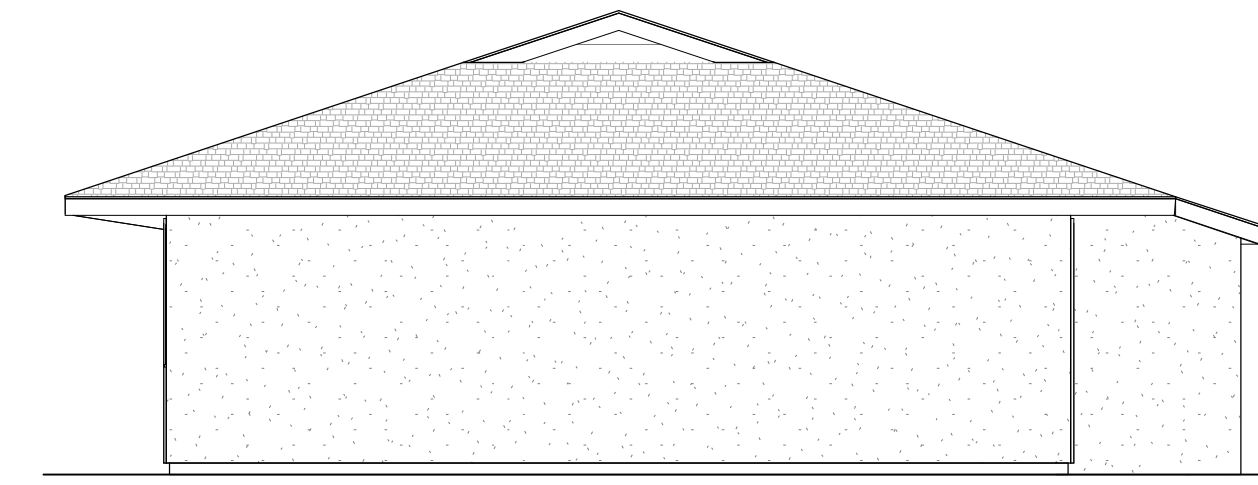

**1 BUILDING 3 FRONT**  
 3/16" = 1'-0"

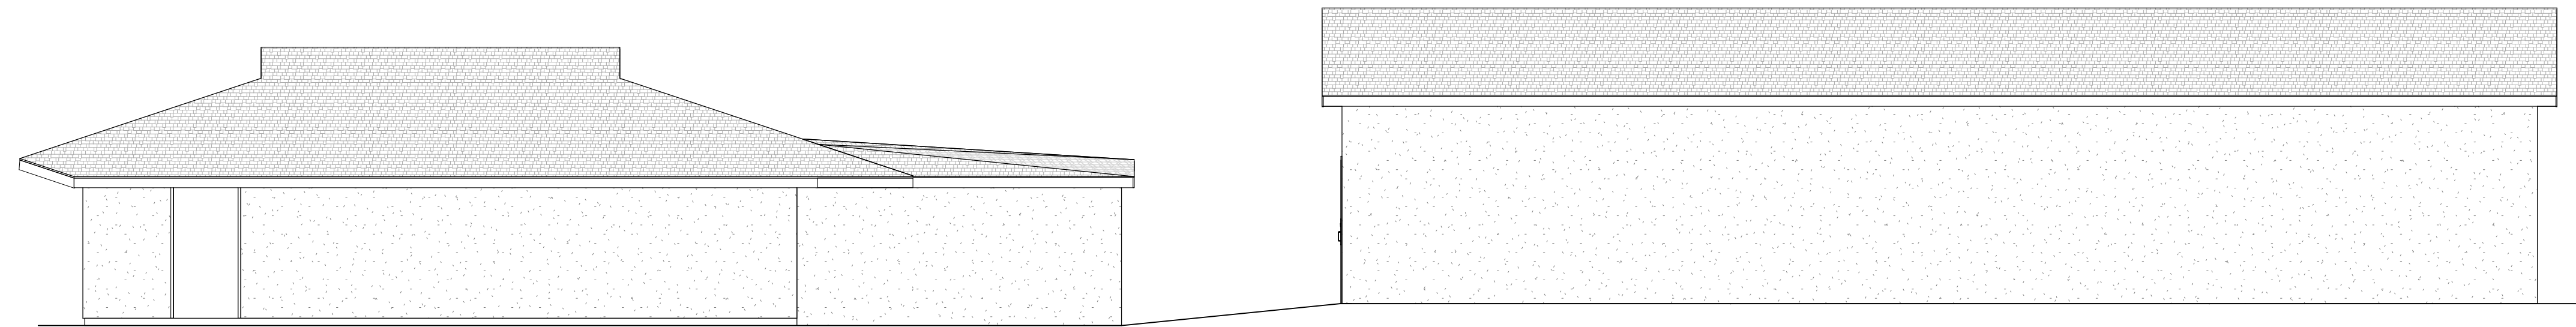

**2 BUILDING 2&3 RIGHT**  
 3/16" = 1'-0"

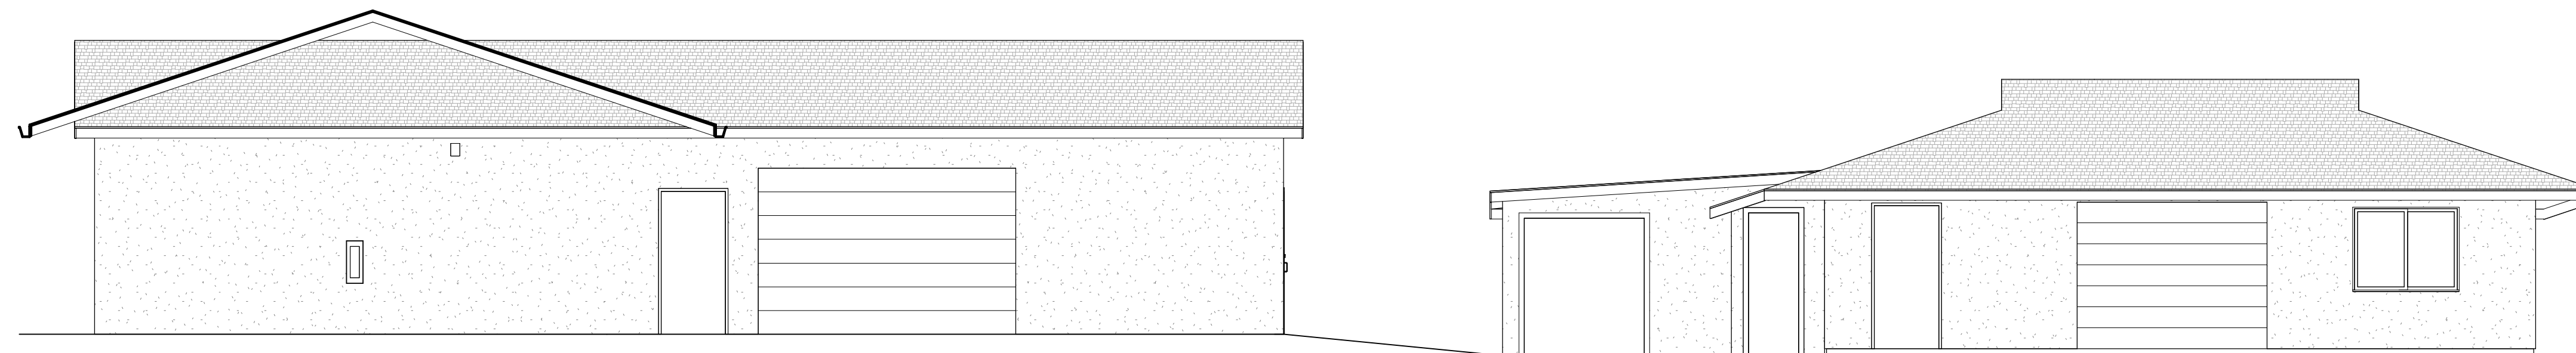

**4 BUILDING 2 LEFT**  
 3/16" = 1'-0"


**ARCHITECTURAL AS BUILT**  
**Point Reyes Station, CA**

01	100% SUBMISSION	SEE COVER SHEET
NO.	ISSUES / REVISIONS	DATE
SHEET TITLE		


**EXTERIOR ELEVATIONS**

Designer	PROJECT MANAGER
Designer	PROJECT DIRECTOR
Project Number	PROJECT NUMBER
Author	DRAWN BY
	SHEET NUMBER


**AB-7**

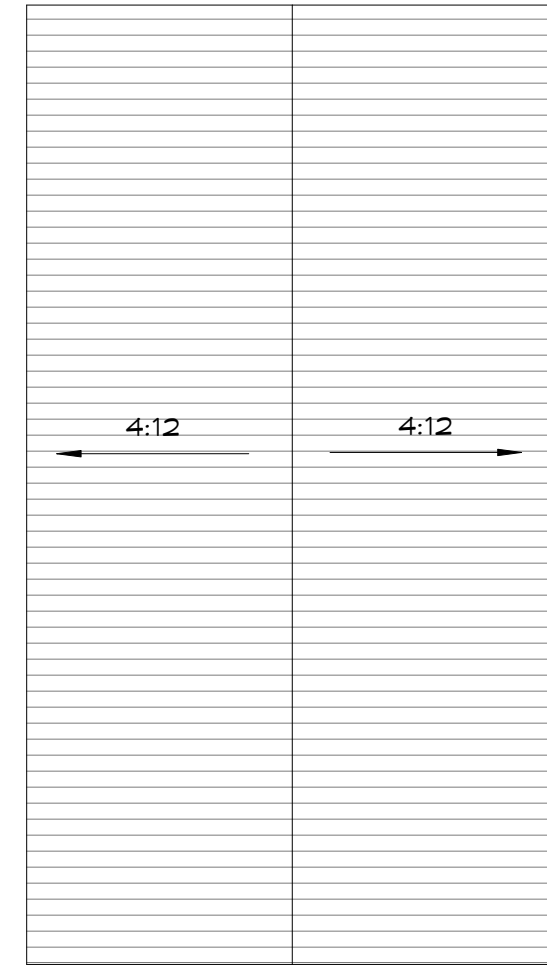


7 CARPORT ROOF PLAN  
1/8" = 1'-0"

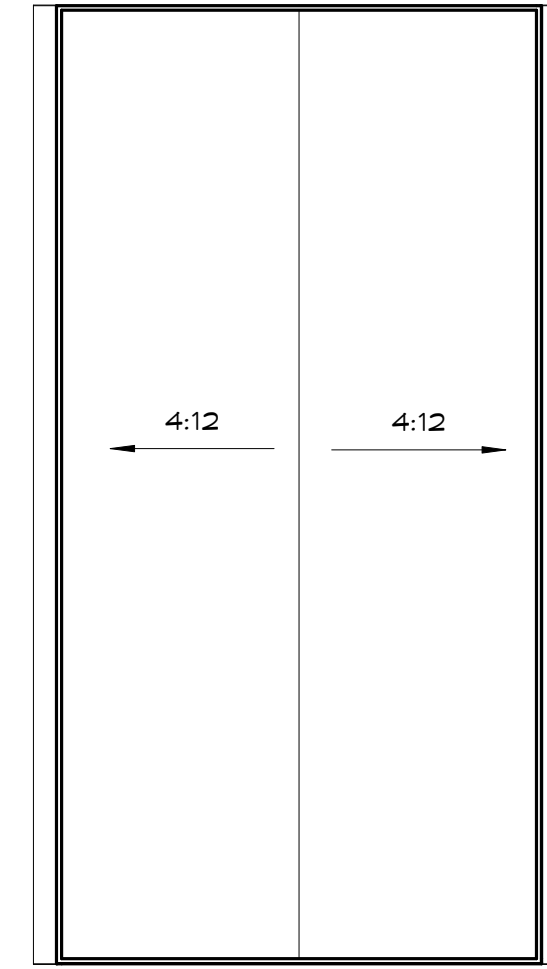


6 CARPORT RCP  
1/8" = 1'-0"

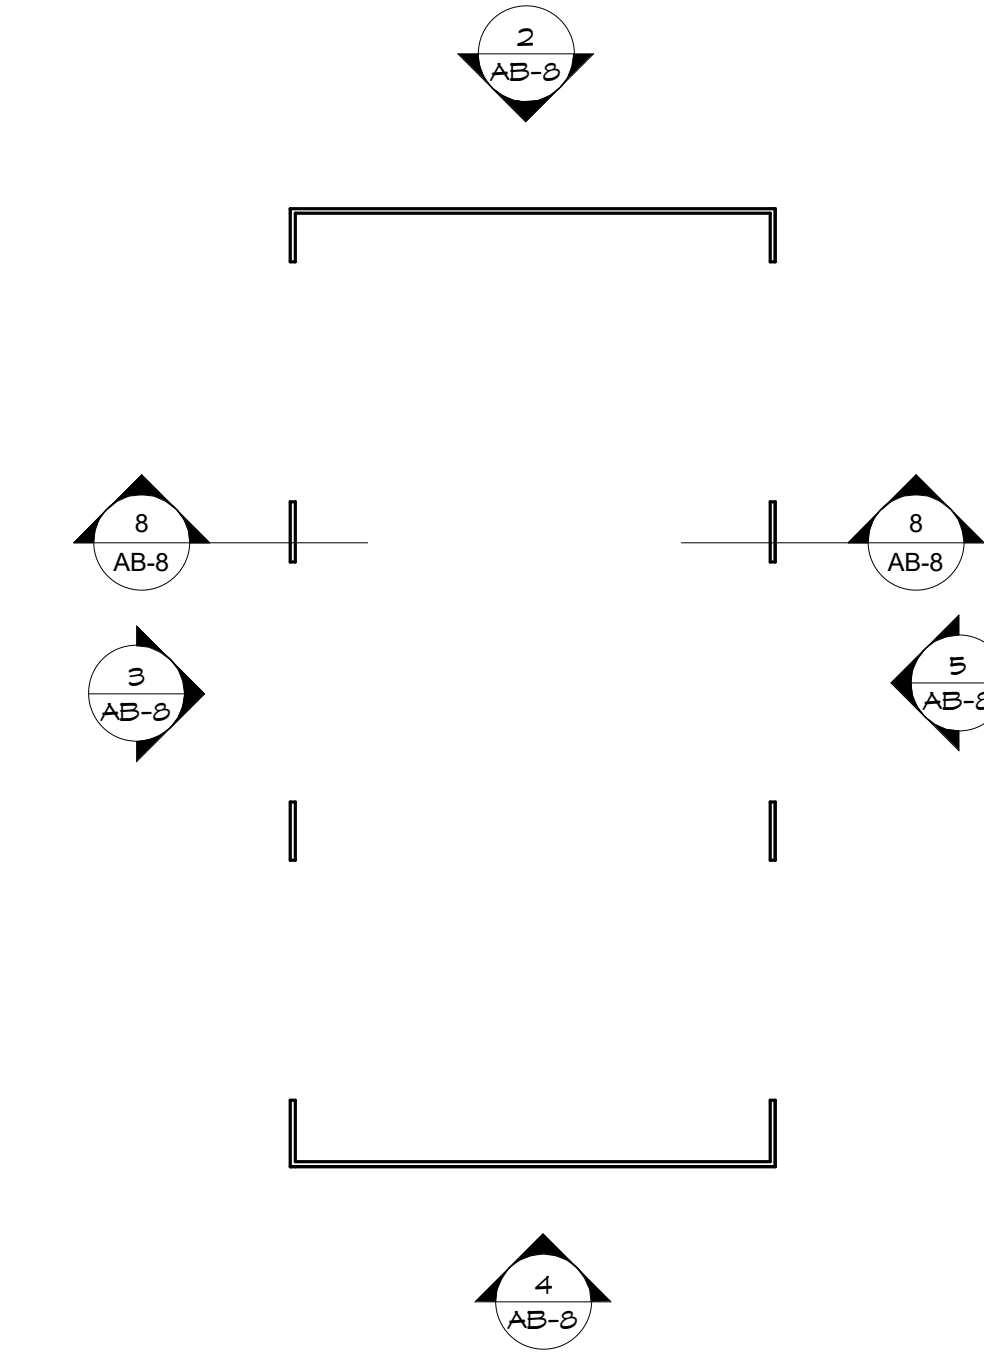


1 CARPORT PLAN  
1/8" = 1'-0"

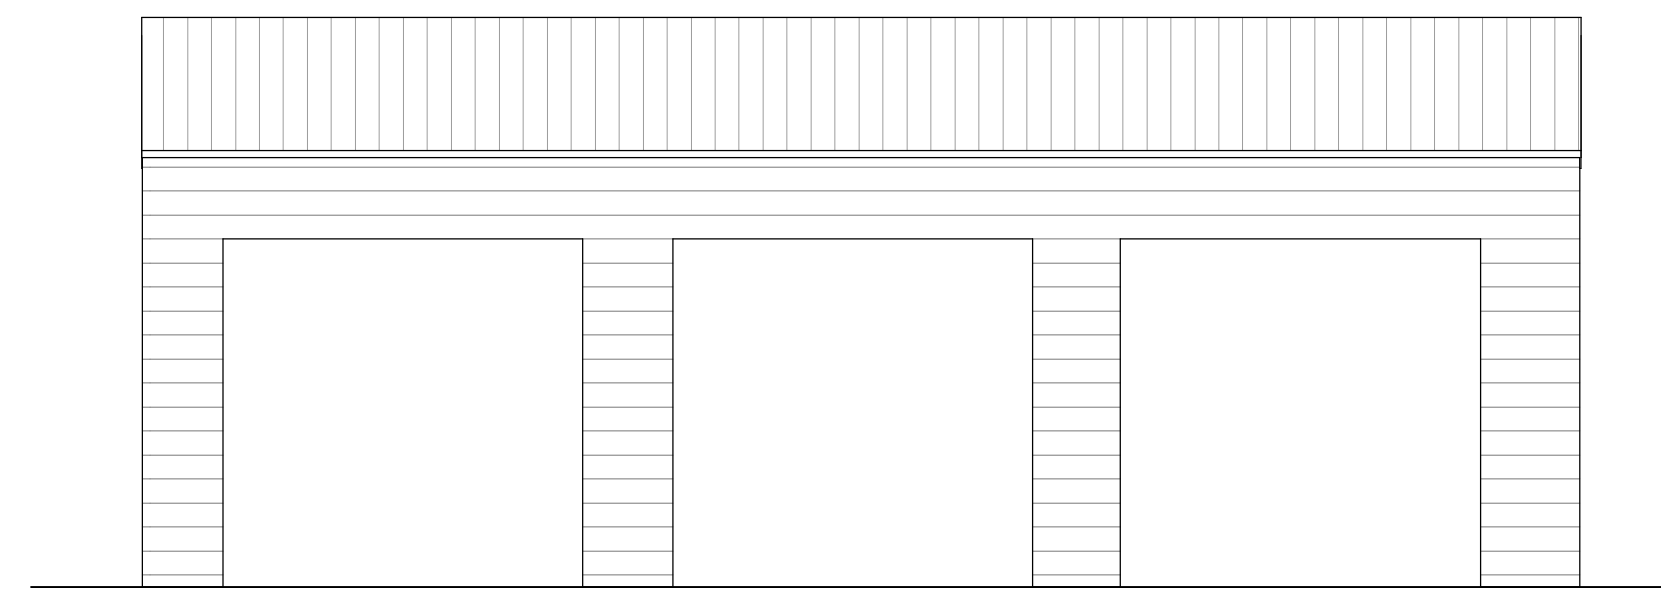


3 CARPORT FRONT  
3/16" = 1'-0"

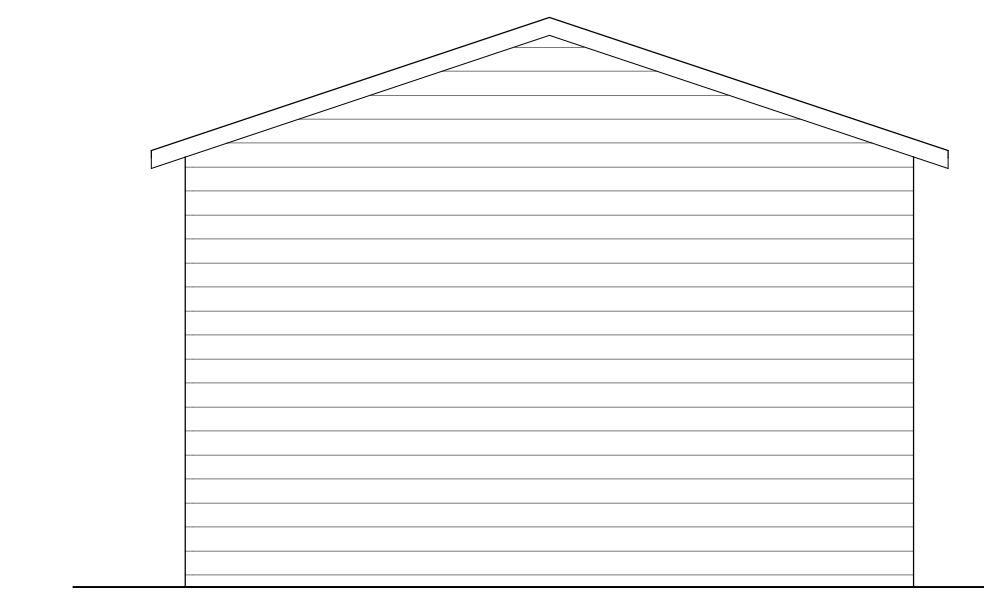


2 CARPORT LEFT  
3/16" = 1'-0"

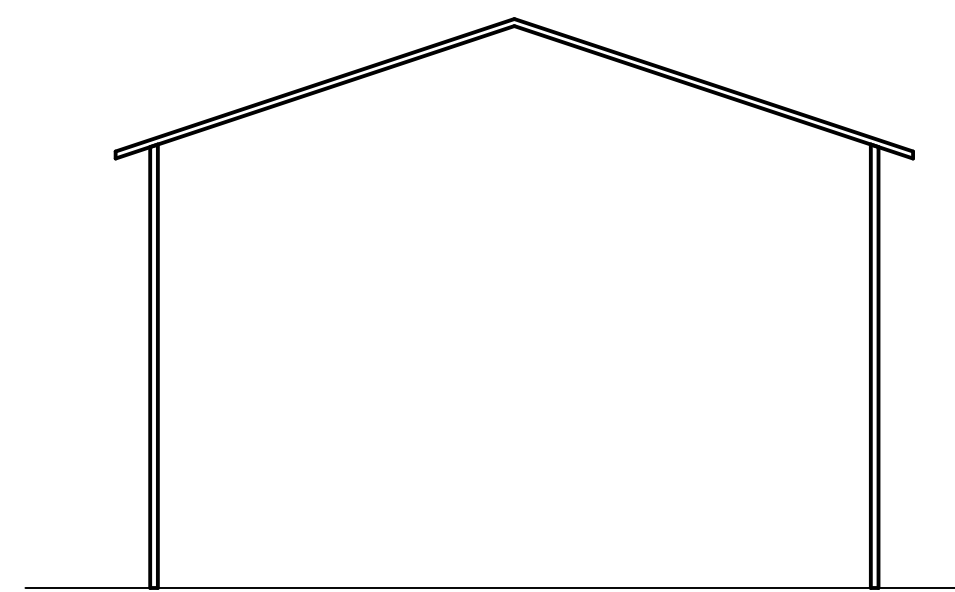

8 CARPORT SECTION  
3/16" = 1'-0"

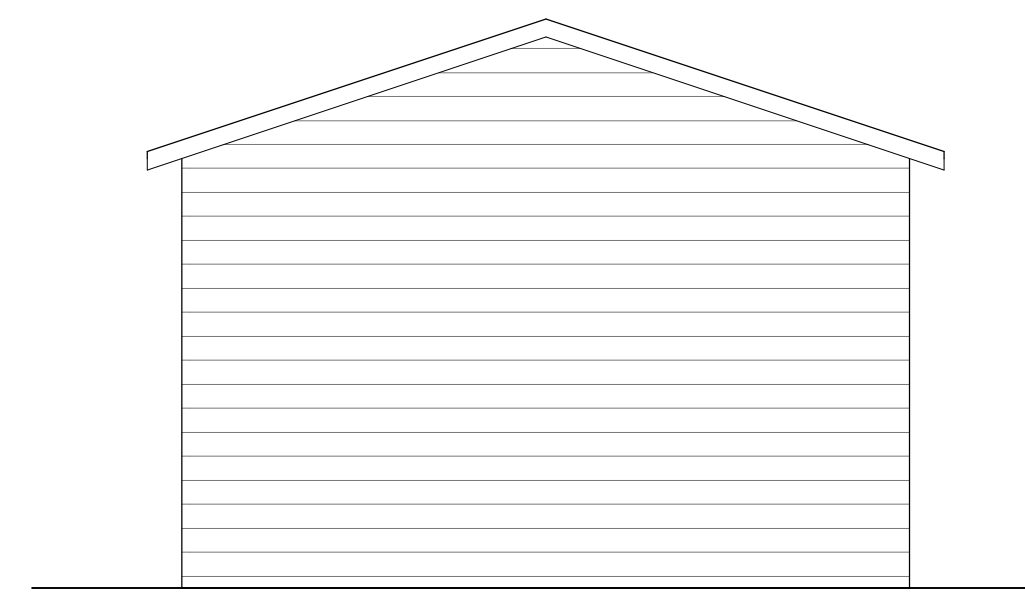

4 CARPORT RIGHT  
3/16" = 1'-0"

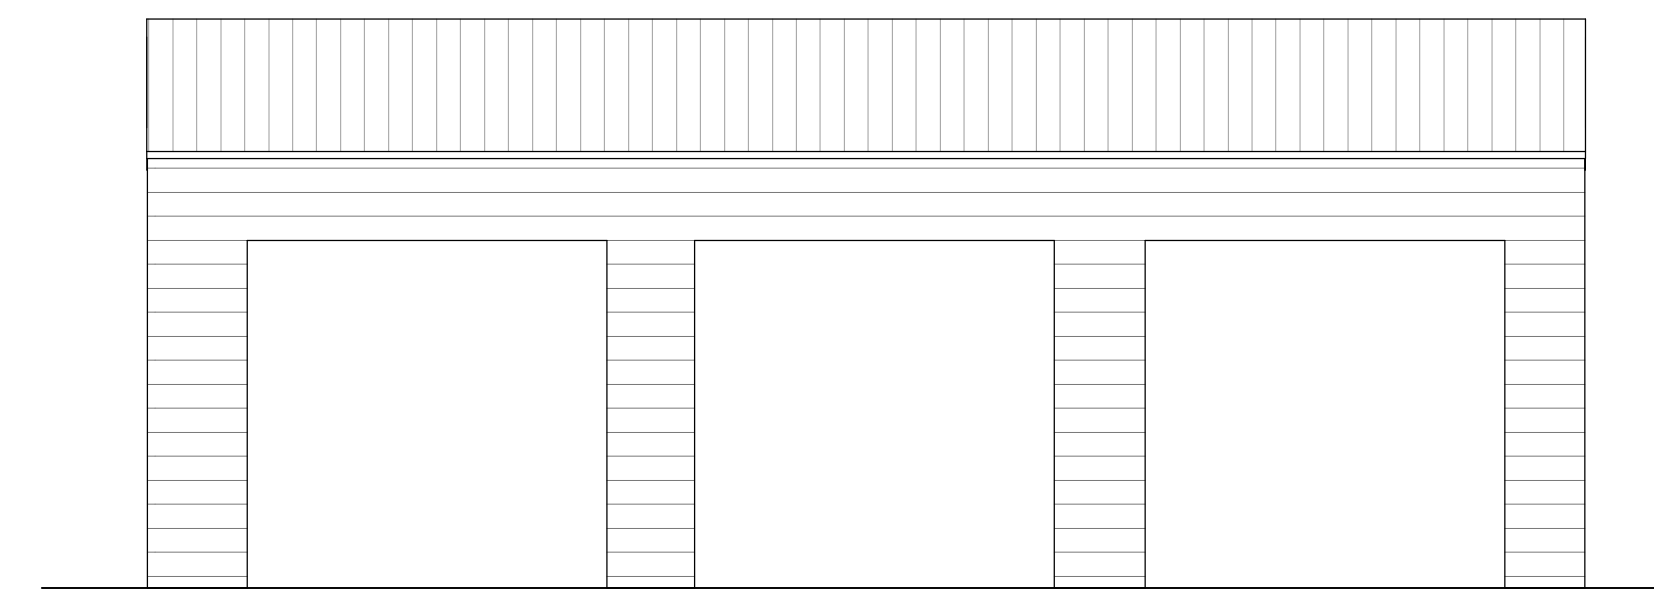

5 CARPORT BACK  
3/16" = 1'-0"

**ARCHITECTURAL AS BUILT**  
**Point Reyes Station, CA**


01	100% SUBMISSION	SEE COVER SHEET
NO.	ISSUES / REVISIONS	DATE

SHEET TITLE  
**CARPORT**


Designer	PROJECT MANAGER
Designer	PROJECT DIRECTOR
Project Number	PROJECT NUMBER
Author	DRAWN BY
	SHEET NUMBER

**AB-8**




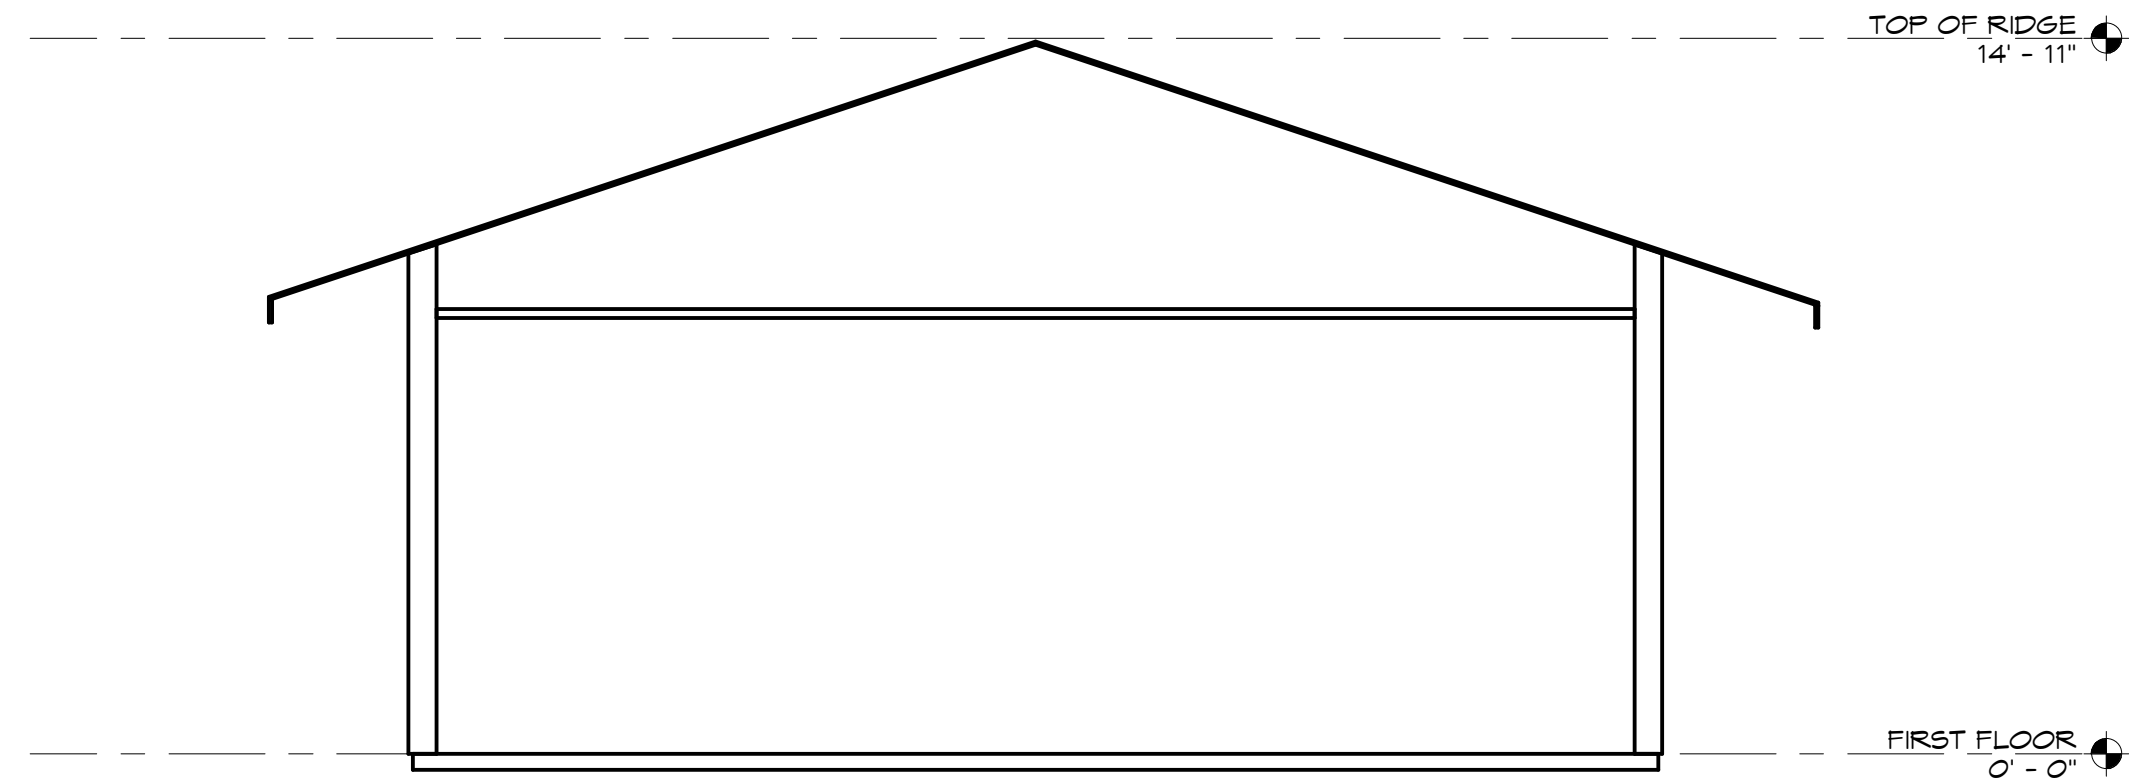

**1 BUILDING 1 SECTION**  
1/4" = 1'-0"

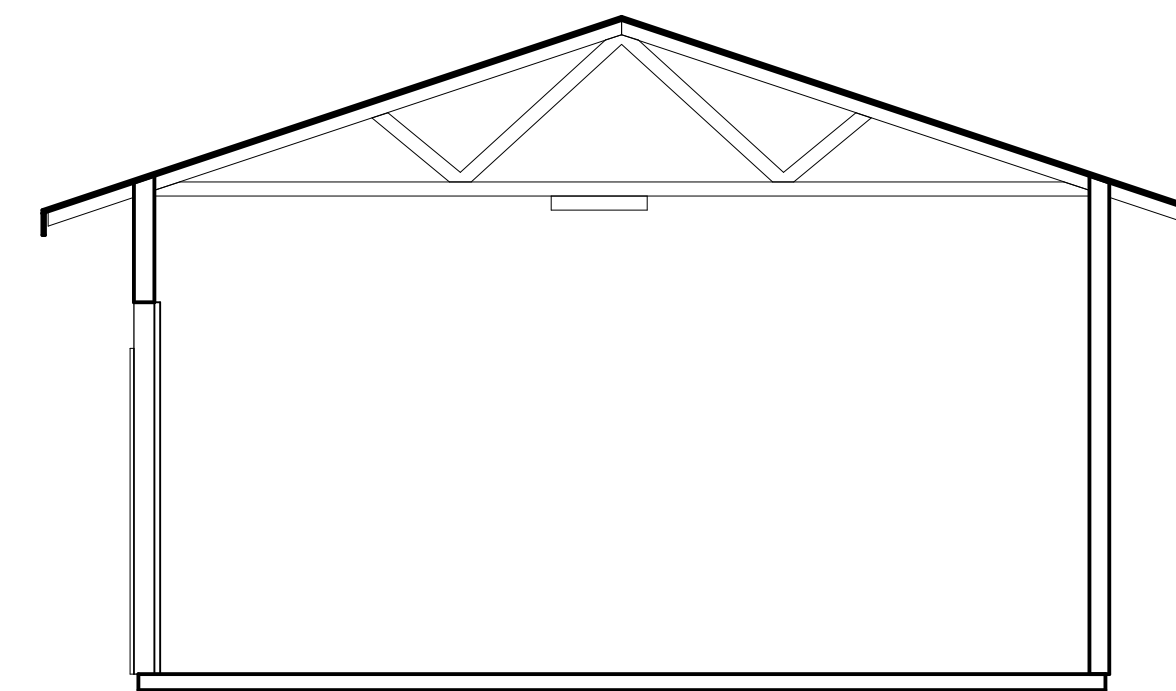

**2 BUILDING 2 SECTION**  
1/4" = 1'-0"

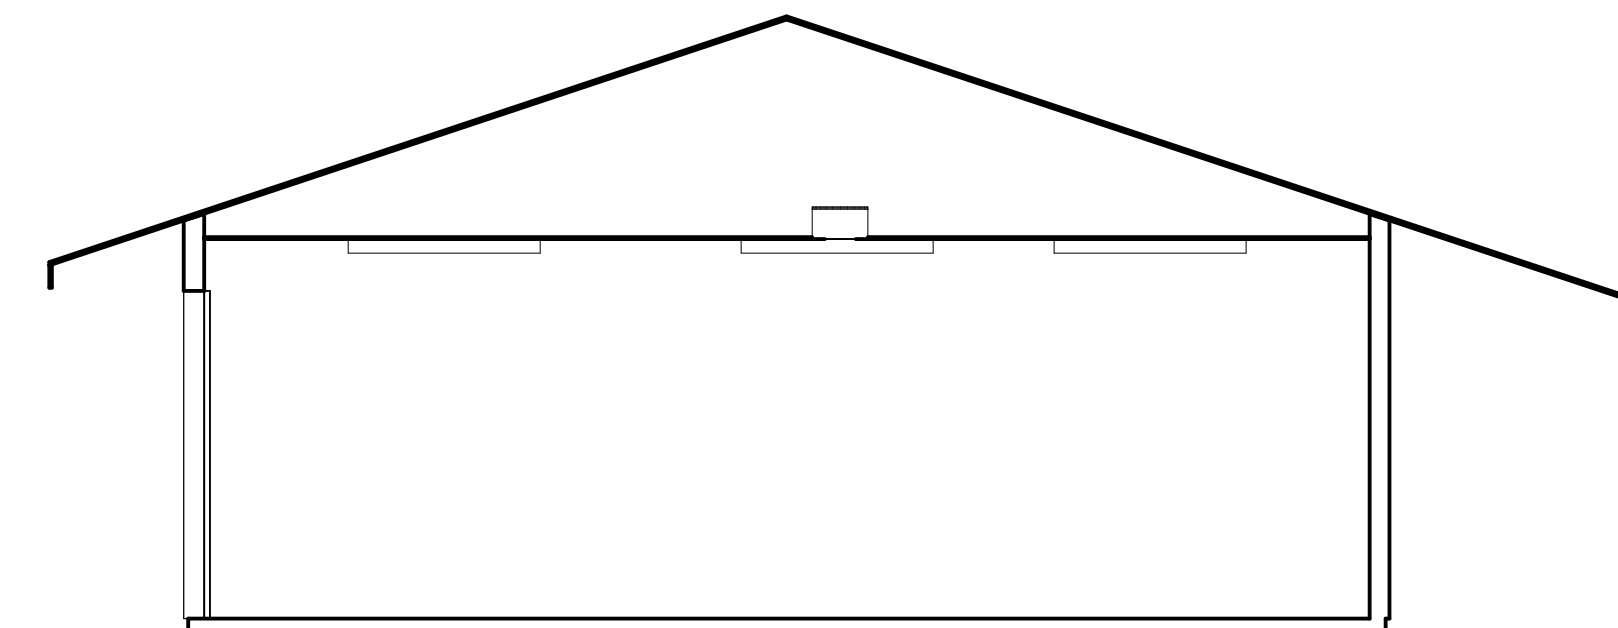


**3 BUILDING 3 SECTION**  
1/4" = 1'-0"

**ARCHITECTURAL AS BUILT**  
**Point Reyes Station, CA**


NO.	ISSUES / REVISIONS	DATE	SHEET TITLE
01	100% SUBMISSION	SEE COVER SHEET	

**BUILDING SECTIONS**


Designer	PROJECT MANAGER
Designer	PROJECT DIRECTOR
Project Number	PROJECT NUMBER
Author	DRAWN BY
	SHEET NUMBER

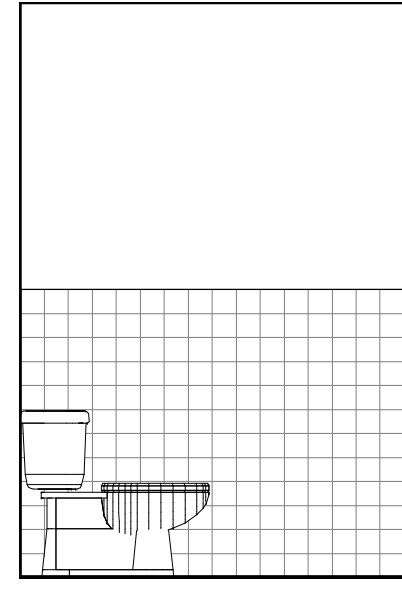


1 NC - A  
3/8" = 1'-0"

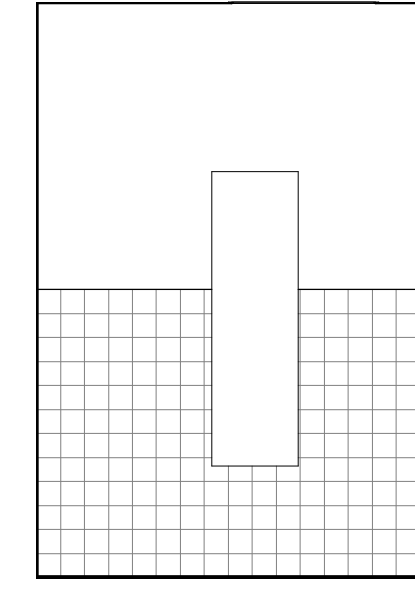

2 NC - B  
3/8" = 1'-0"

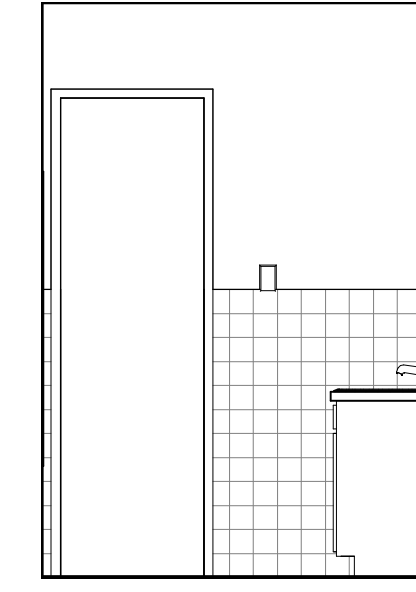

3 NC - C  
3/8" = 1'-0"

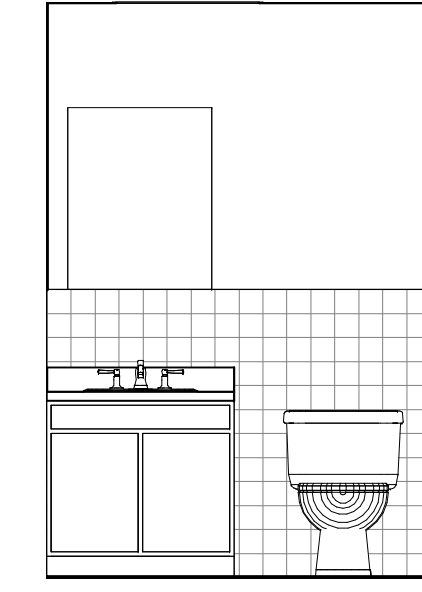

4 NC - D  
3/8" = 1'-0"


**ARCHITECTURAL AS BUILT**  
**Point Reyes Station, CA**

NO.	ISSUES / REVISIONS	DATE
01	100% SUBMISSION	SEE COVER SHEET

**INTERIOR ELEVATIONS**

Designer	PROJECT MANAGER
Designer	PROJECT DIRECTOR
Project Number	PROJECT NUMBER
Author	DRAWN BY
	SHEET NUMBER



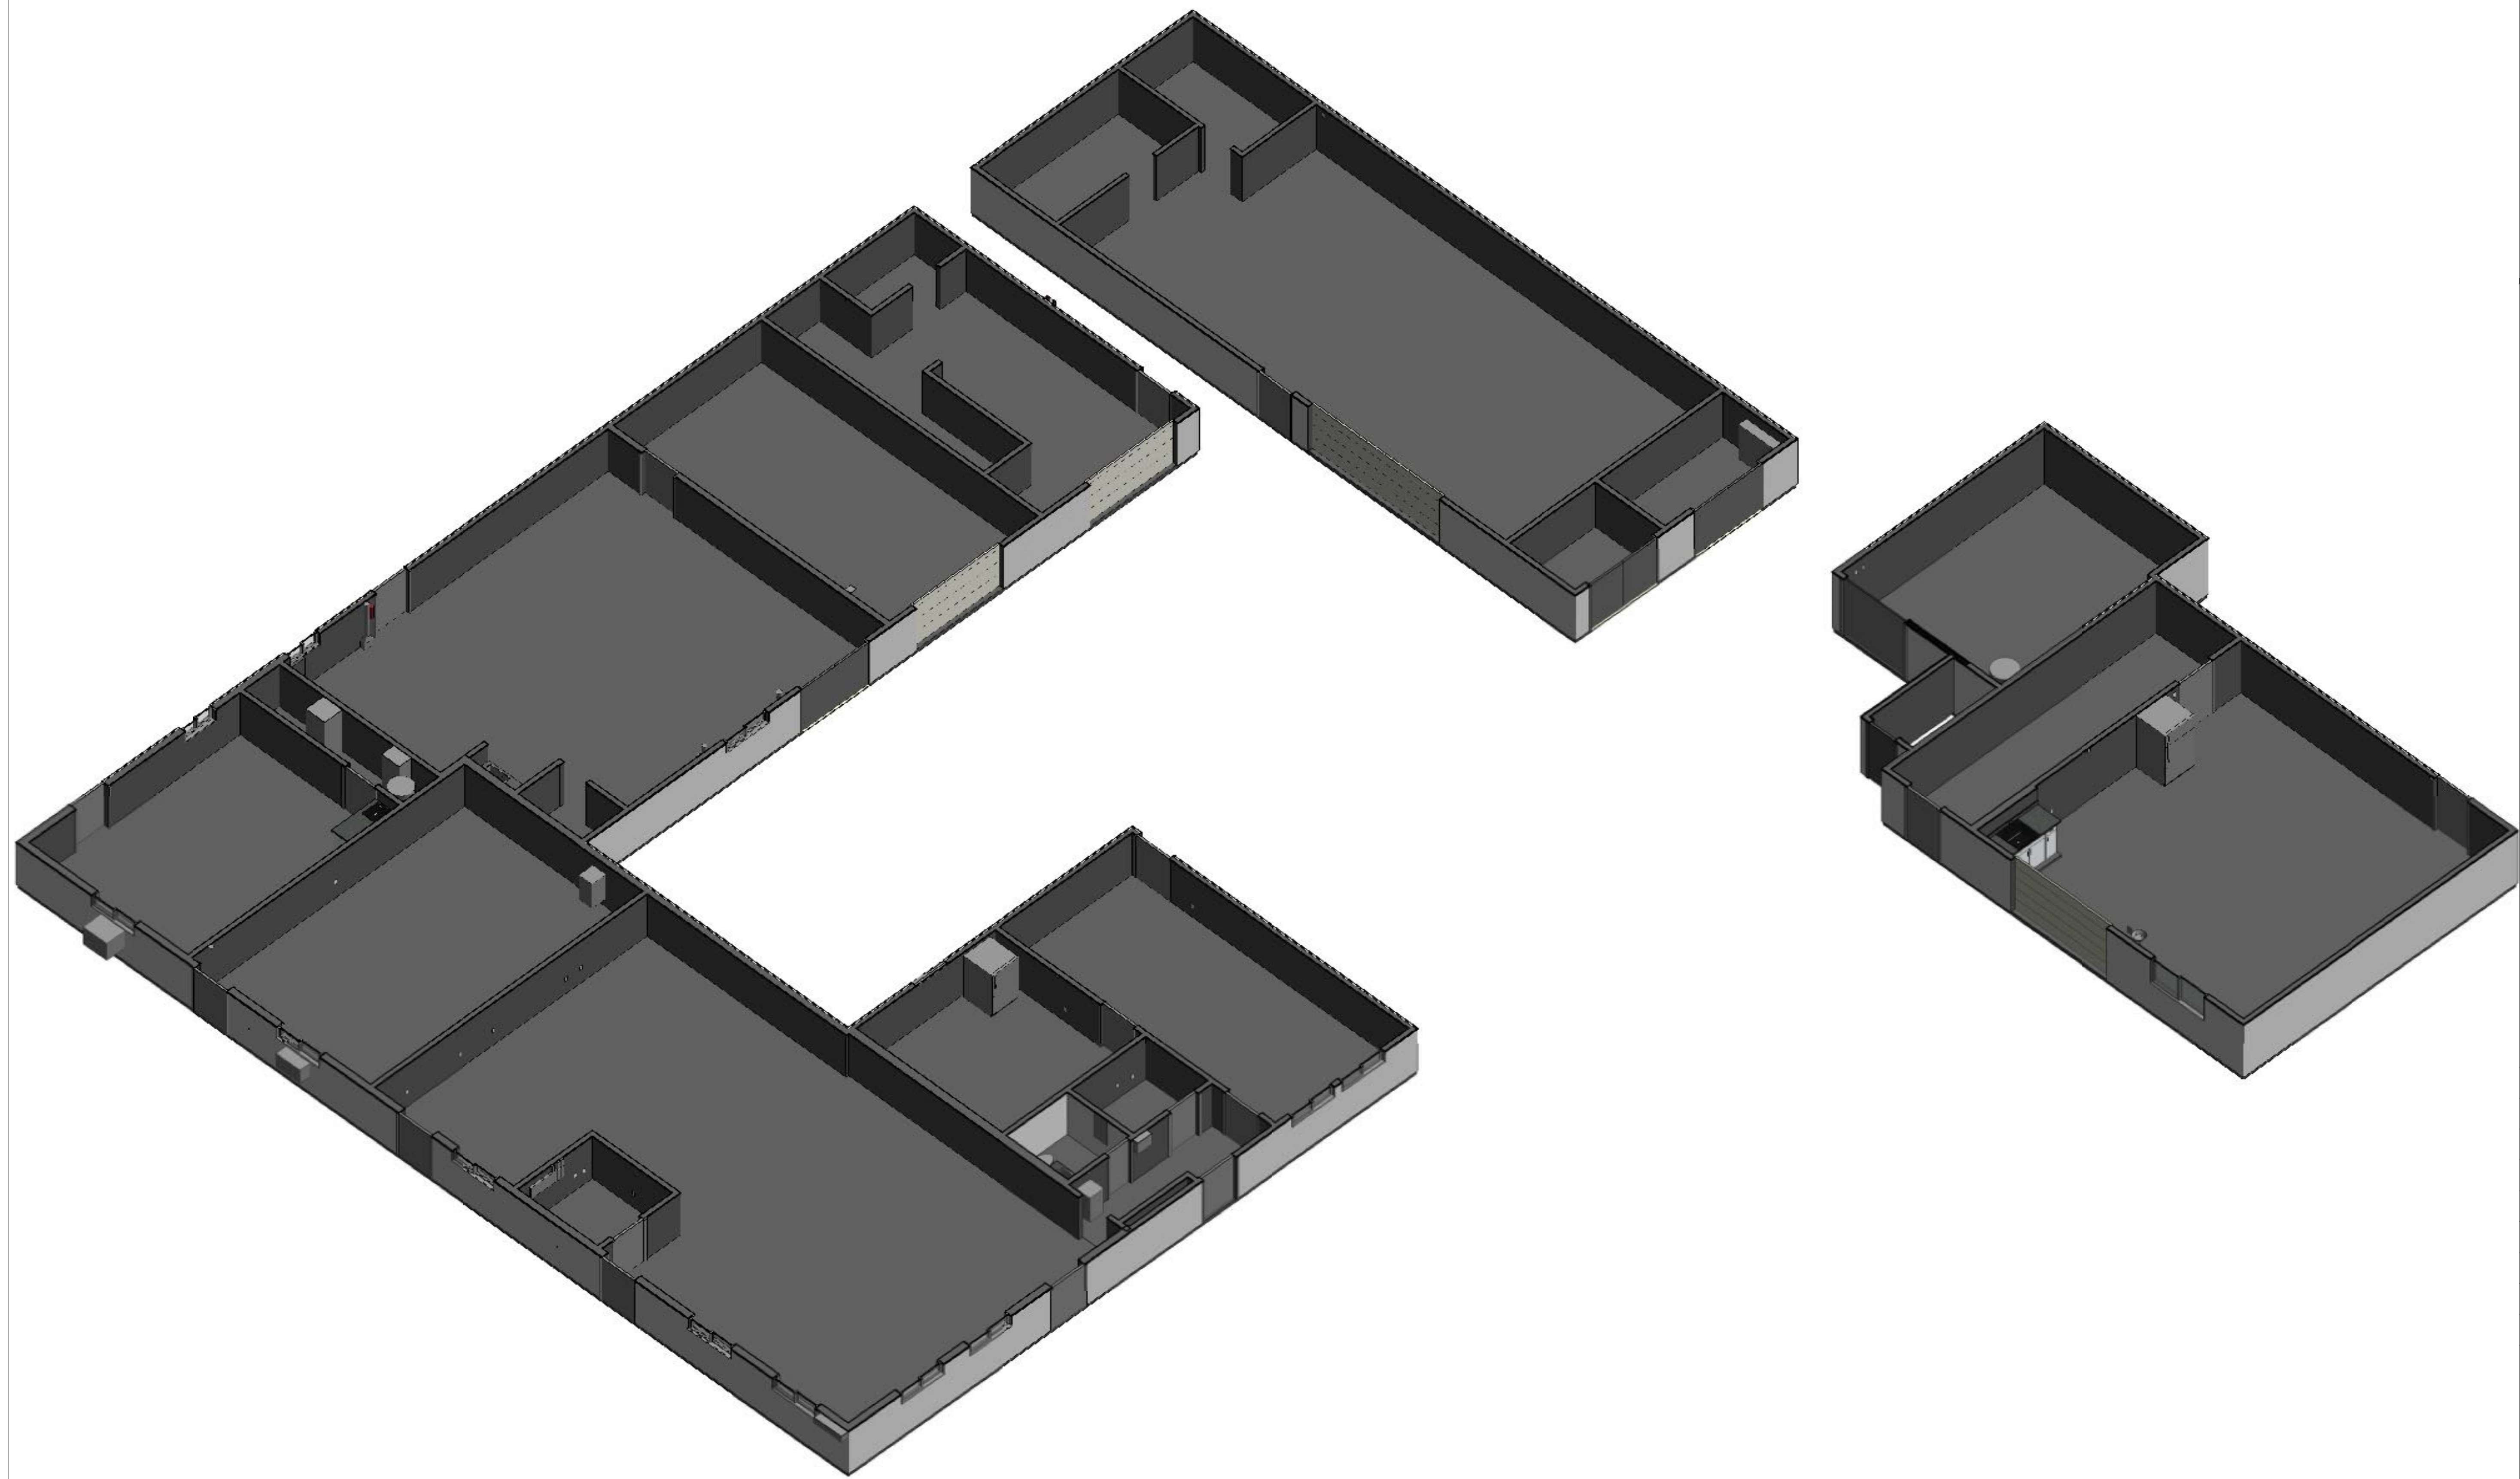

**ARCHITECTURAL AS BUILT**  
**Point Reyes Station, CA**

NO.	ISSUES / REVISIONS	DATE	SHEET TITLE
01	100% SUBMISSION		SEE COVER SHEET

**3D PLAN SECTION**

Designer	PROJECT MANAGER
Designer	PROJECT DIRECTOR
Project Number	PROJECT NUMBER
Author	DRAWN BY
	SHEET NUMBER

**AB-11**






**ARCHITECTURAL AS BUILT**  
**Point Reyes Station, CA**

NO.	ISSUES / REVISIONS	DATE
01	100% SUBMISSION	SEE COVER SHEET



**3D ELEVATIONS**

Designer	PROJECT MANAGER
Designer	PROJECT DIRECTOR
Project Number	PROJECT NUMBER
Author	DRAWN BY
	SHEET NUMBER

**AB-12**

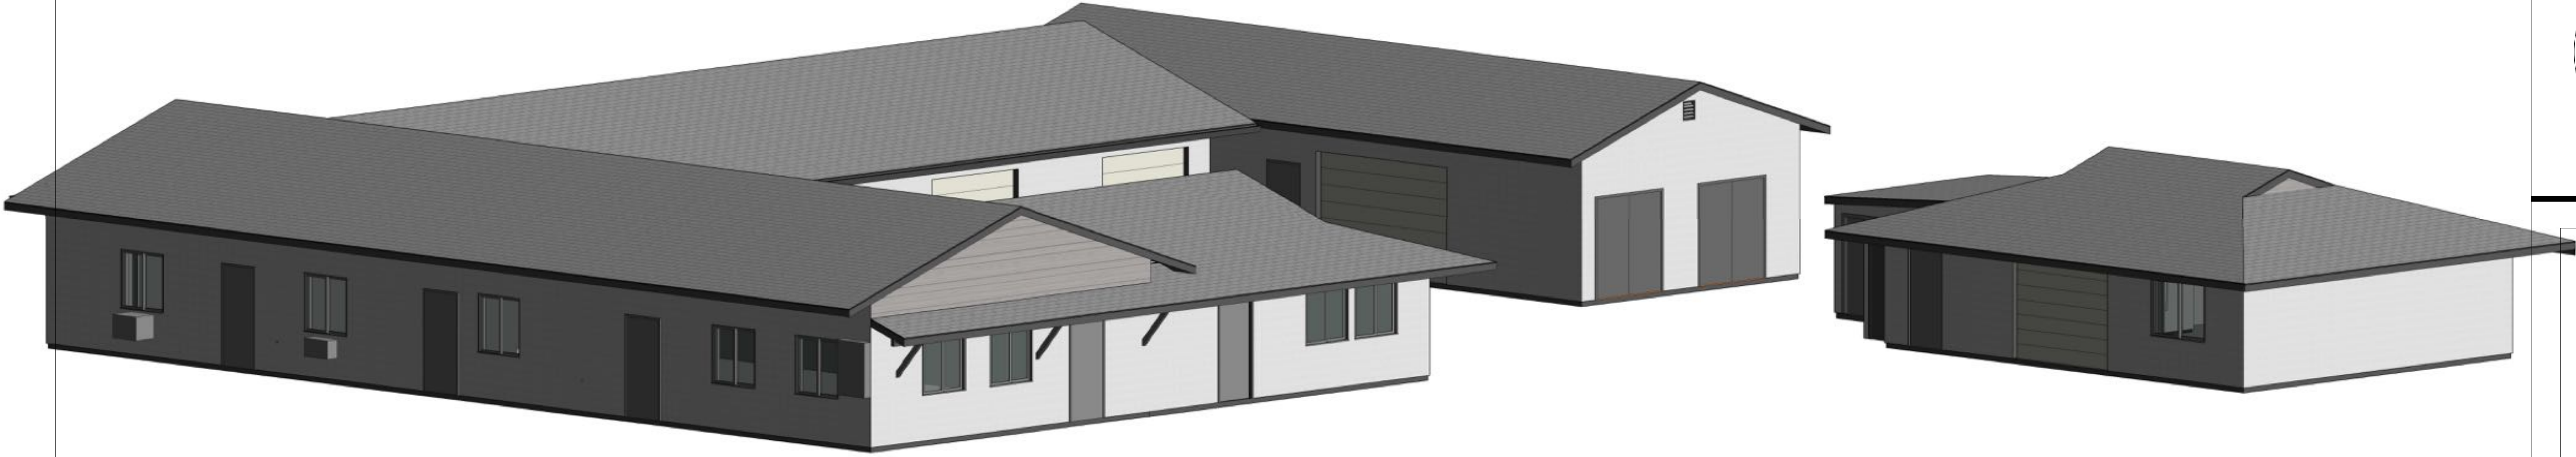



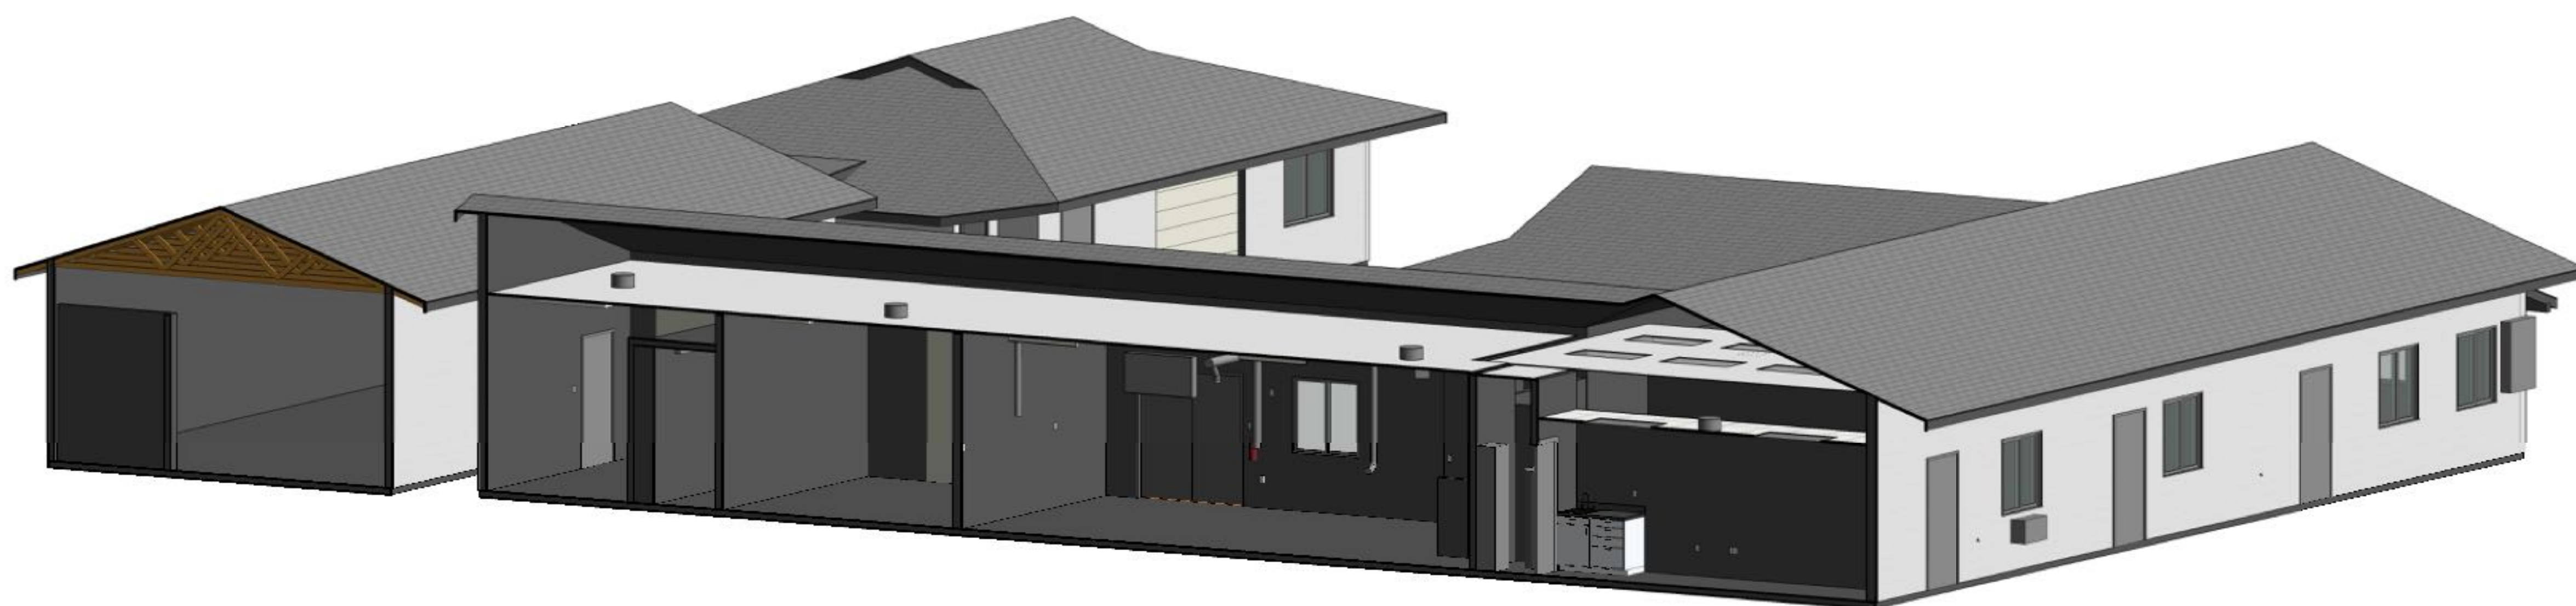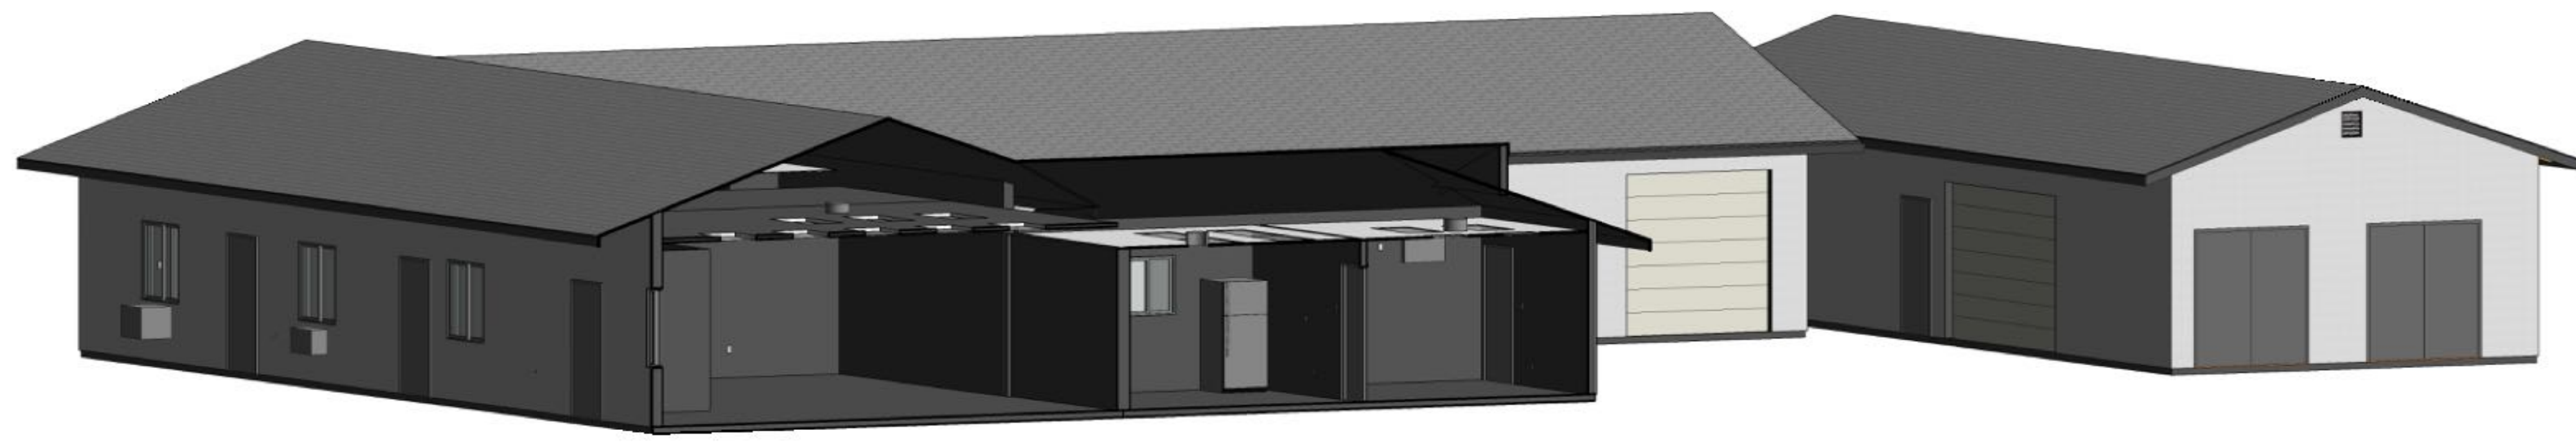

**ARCHITECTURAL AS BUILT**  
**Point Reyes Station, CA**

01	100% SUBMISSION	SEE COVER SHEET
NO.	ISSUES / REVISIONS	DATE
		SHEET TITLE

**3D SECTIONS**

Designer	PROJECT MANAGER
Designer	PROJECT DIRECTOR
Project Number	PROJECT NUMBER
	SCALE
Author	DRAWN BY
	SHEET NUMBER

**AB-13**